


2  
PL101A10

**ENLARGED PLUMBING PLAN**

SCALE: 1/4" = 1'-0"

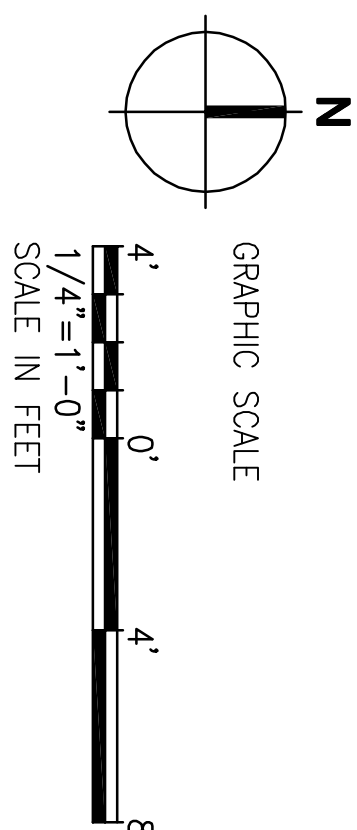

# FINAL SUBMISSION / FULLY SPRINKLERED

CONSULTANTS:		ARCHITECT/ENGINEERS:		Drawing Title		Project Number		Office of Construction and Facilities Management	
CML, INC. 4000 W. 10TH AVE. SUITE 400 DENVER, CO. 80202 TEL: (303) 733-1100 FAX: (303) 733-1101		COM/AFS 2600 RACINE BLVD. SUITE 200 PLEASANTON, CA 94566 TEL: (925) 471-0000 FAX: (925) 471-0003		BCD CIVIL 10000 E. 10TH AVE. SUITE 300 DENVER, CO. 80231 TEL: (303) 755-8831 FAX: (303) 755-8831		ENLARGED PLUMBING PLAN, DWG OVERALL LAYOUT ALTERNATE WORK		520-326 - Building Number	
LANDSCAPE ARCHITECT: 6300 PICOAVENUE SQUARE DRIVE DENVER, CO. 80231 TEL: (303) 344-4023 FAX: (303) 344-4022		SPRINTERS: LANDSCAPE ARCHITECTS, INC. 10401 HOLLAND AVENUE, SUITE 120 DENVER, CO. 80231 TEL: (303) 746-2000 FAX: (303) 746-2000		BES DESIGN/BUILD, LLC 766 Middle St., Fairhope, AL 36692 Phone: 251.990.5778 Fax: 251.990.3716		Location PANAMA CITY, FLORIDA		Drawing Number PL404A10	
Date				Date APRIL 2010		Checked WMS		of 4 Dwg. 3	
Drawings				Approved Project Director		Drafting		Design/Engineering Veterans Affairs	