

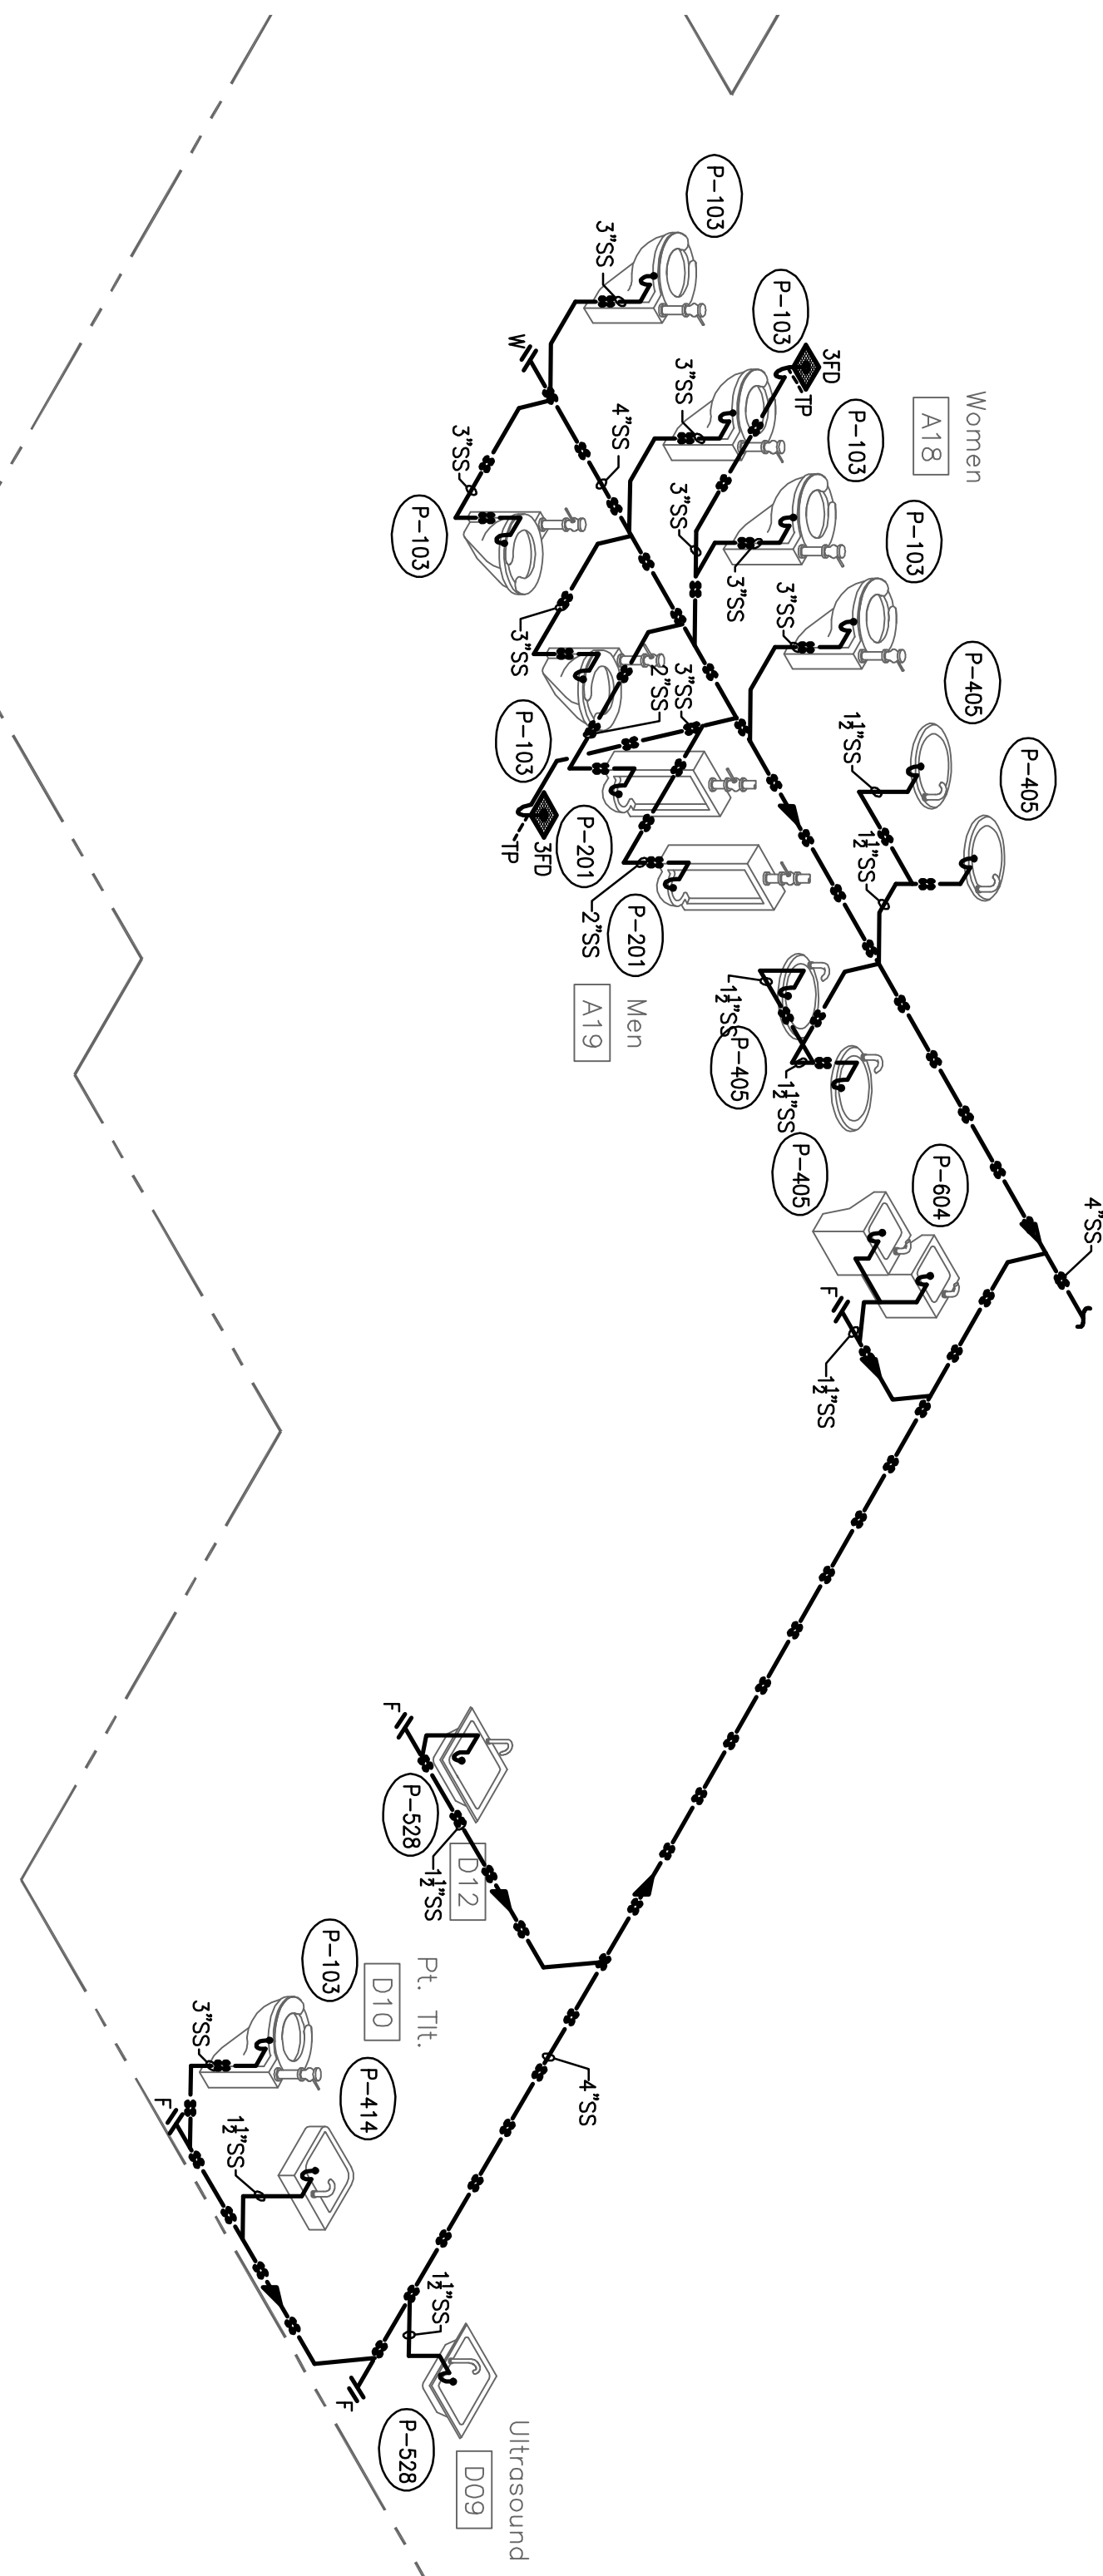
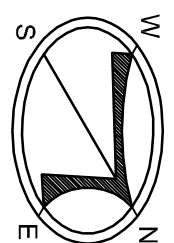


1 PLUMBING RISER DIAGRAM HOT/COLD WATER

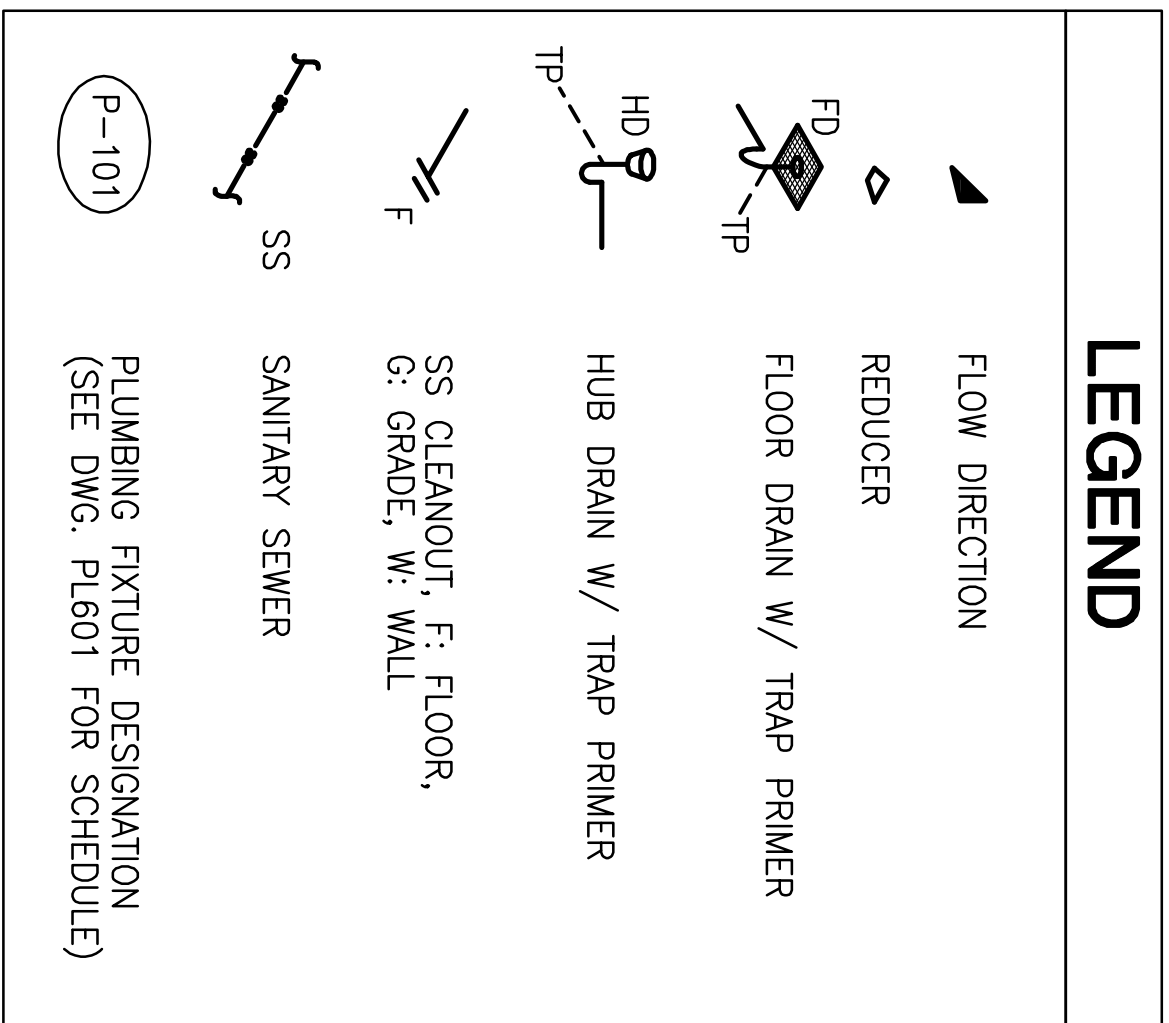

2 PLUMBING RISER DIAGRAM SANITARY SEWER

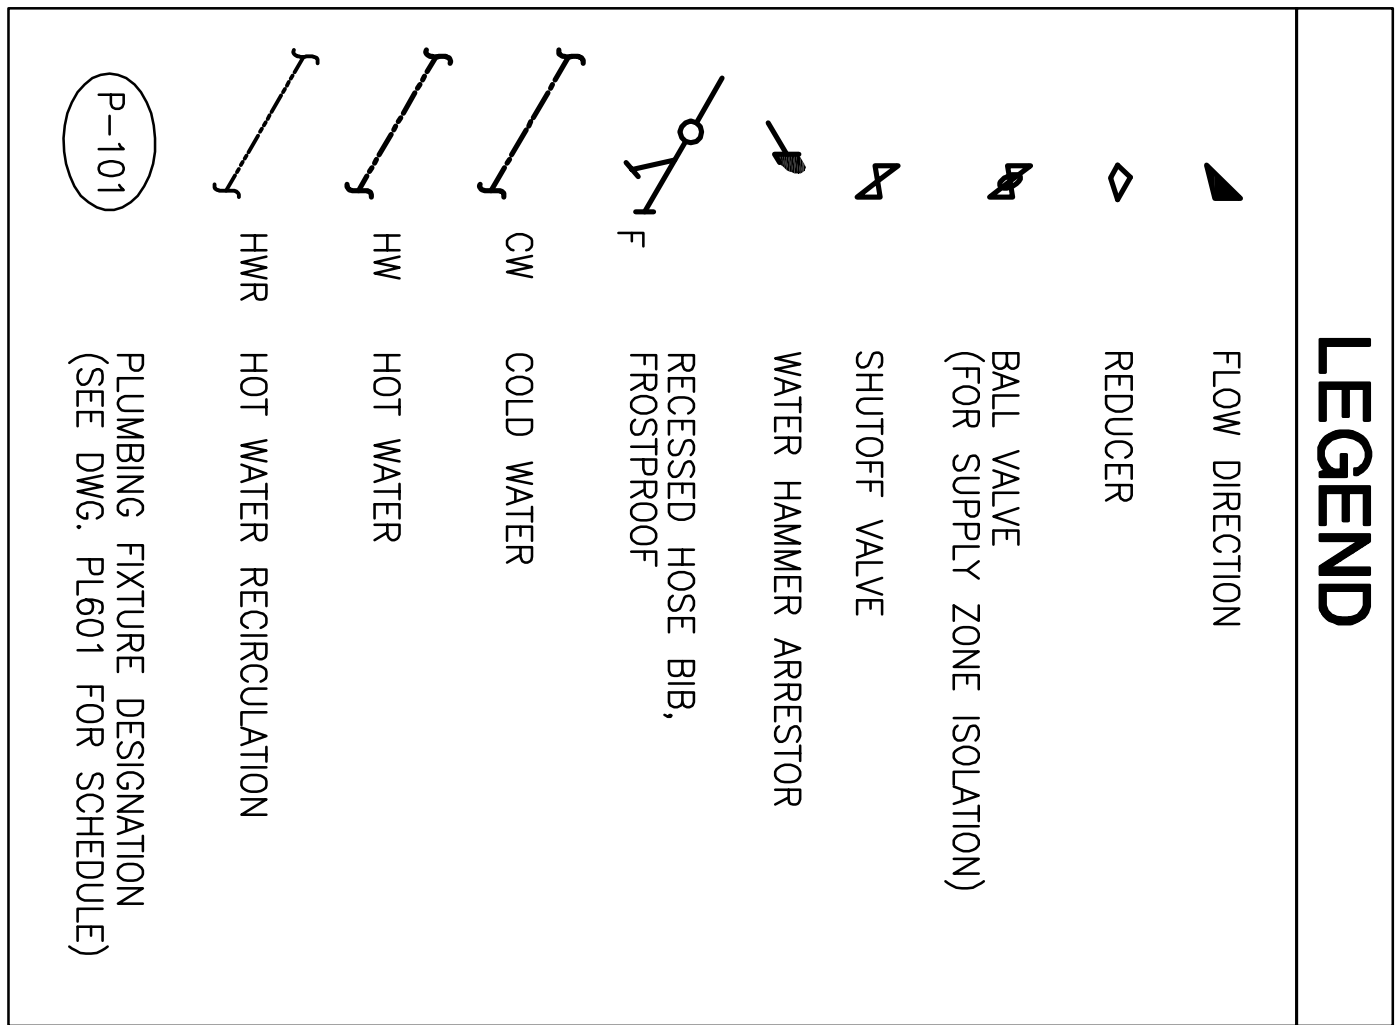

- NOTES:
1. RISER DIAGRAM IS INTENDED AS A SCHEMATIC AND MAY NOT REPRESENT THE ACTUAL PHYSICAL LOCATION OR CORRECT GRAPHIC REPRESENTATION OF FIXTURES TO BE INSTALLED. PLEASE REFER TO THE PLUMBING PLANS AND SCHEDULE FOR MORE INFORMATION.
 2. PLUMBING ISOLATION ZONE VALVE LOCATIONS SHALL BE REPRESENTED BY BLUE DOT LABELS ON THE CEILING.
 3. ALL COLD, HOT AND RECIRC. PIPING TO BE INSTALLED ABOVE THE CEILING.

FINAL SUBMISSION / FULLY SPRINKLERED

CONSULTANTS:		ARCHITECT/ENGINEERS:	
DATE		Drawing Title	PLUMBING RISER DIAGRAM COLD / HOT WATER AND SS ALTERNATE WORK
		Project Title	CONSTRUCT VA OUTPATIENT CLINIC, PANAMA CITY
		Project Number	520-326
		Building Number	-
		Drawing Number	PL503A10
		Location	PANAMA CITY, FLORIDA
		Date	APRIL 2018
		Checked	WMB
		Drawn	JLL
		Dwg. # of	4 of 4
		Office of Construction and Facilities Management	
		Department of Veterans Affairs	