

Yvonne C. Aglin
Western Team Director

Approved Project Director

ARCHITECT
The Ratcliff Architects
5856 Doyle Street
Emeryville, CA 94608

P.O. Box 1022
Berkeley, CA 94701
(510) 682-1972

ASSOCIATE ARCHITECT
Stone, Marracini and Patterson
One Market Plaza
Spear Street Tower, Suite 400
San Francisco, CA 94105
(415) 227-0100

CONSULTANTS

Structural Engineers
H.J. Jerngkols Associates

Mechanical Engineers
Capital Engineering Consultants, Inc.

Electrical Engineers
The Engineering Enterprise

Cost Estimator
Adamson Associates



Landscape Design/
Land Planning
Omni Land Associates, Inc.

Civil Engineer
Sandia and Associates, Inc.

Elevator Consultant
Sykes and Hennessy

Fire Protection
Rolf Jensen and Associates

Food Service Consultant
Cini-Little International, Inc.

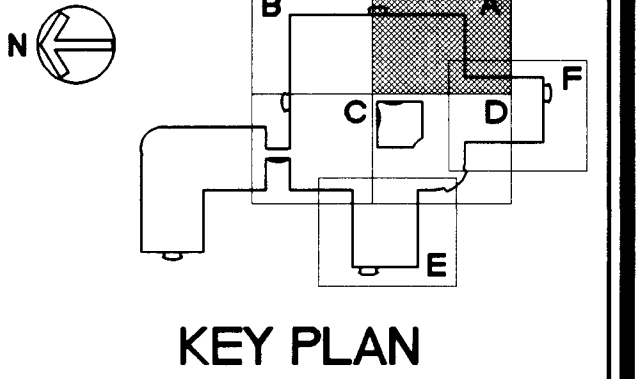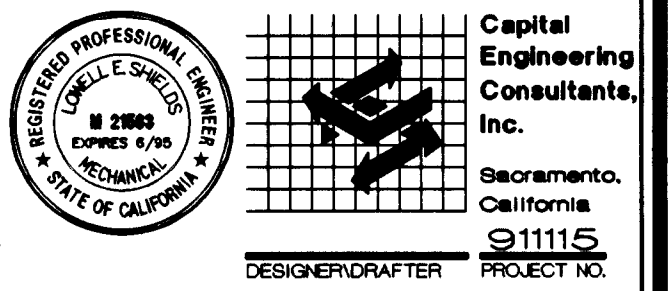

RECORD DRAWINGS 8-14-98

Revisions Date

Location VA Medical Center
Palo Alto, CA

Project Title
**REPLACE CLINICAL/
BED TOWER FOR
SEISMIC CORRECTIONS**

FULLY SPRINKLERED

TRA Project No. 93007 Checked TGI Drawn DA

Drawing Title

**FOURTH FLOOR
PLAN, AREA A -
PIPING**

Scale 1/8" = 1'-0"


VA Project No. 640-042G Building Number 100

Date 2 MAY 1998 DRAWING NO. H2.4.2A

Page of

SHEET NOTE:

- ① INSTALL A TEMPERATURE SENSOR (DDC) IN THE RETURN AIR DUCT, USE TO CONTROL THE AHU'S #/OR REHEAT COILS.
- ② FOR CHILLED WATER SYSTEM SCHEMATIC SEE H6.1.1.
FOR HEATING WATER RISER DIAGRAM SEE H7.2.1.
FOR STEAM & STEAM CONDENSATE RETURN RISER DIAGRAM SEE H7.4.1.
- ③ MPS (30), MPR, SCH, SCHR UP TO AHU ON ROOF.
- ④ SEE 5/H3.3.1 FOR SHAFT M1 PLAN.
- ⑤ MPS (30), MPR, SGSCH, SGSCHR UP TO AHU ON ROOF.
- ⑥ ① DESIGNATES SENSOR TS-4, REFER TO CONTROL DIAGRAM SHEET H5.2.1.
- ⑦ 3" V FB, SEE SHEET H7.4.1 FOR RISER DIAGRAM.
- ⑧ 3" V, SLOPE DOWN AT MIN. OF 6"/FT.

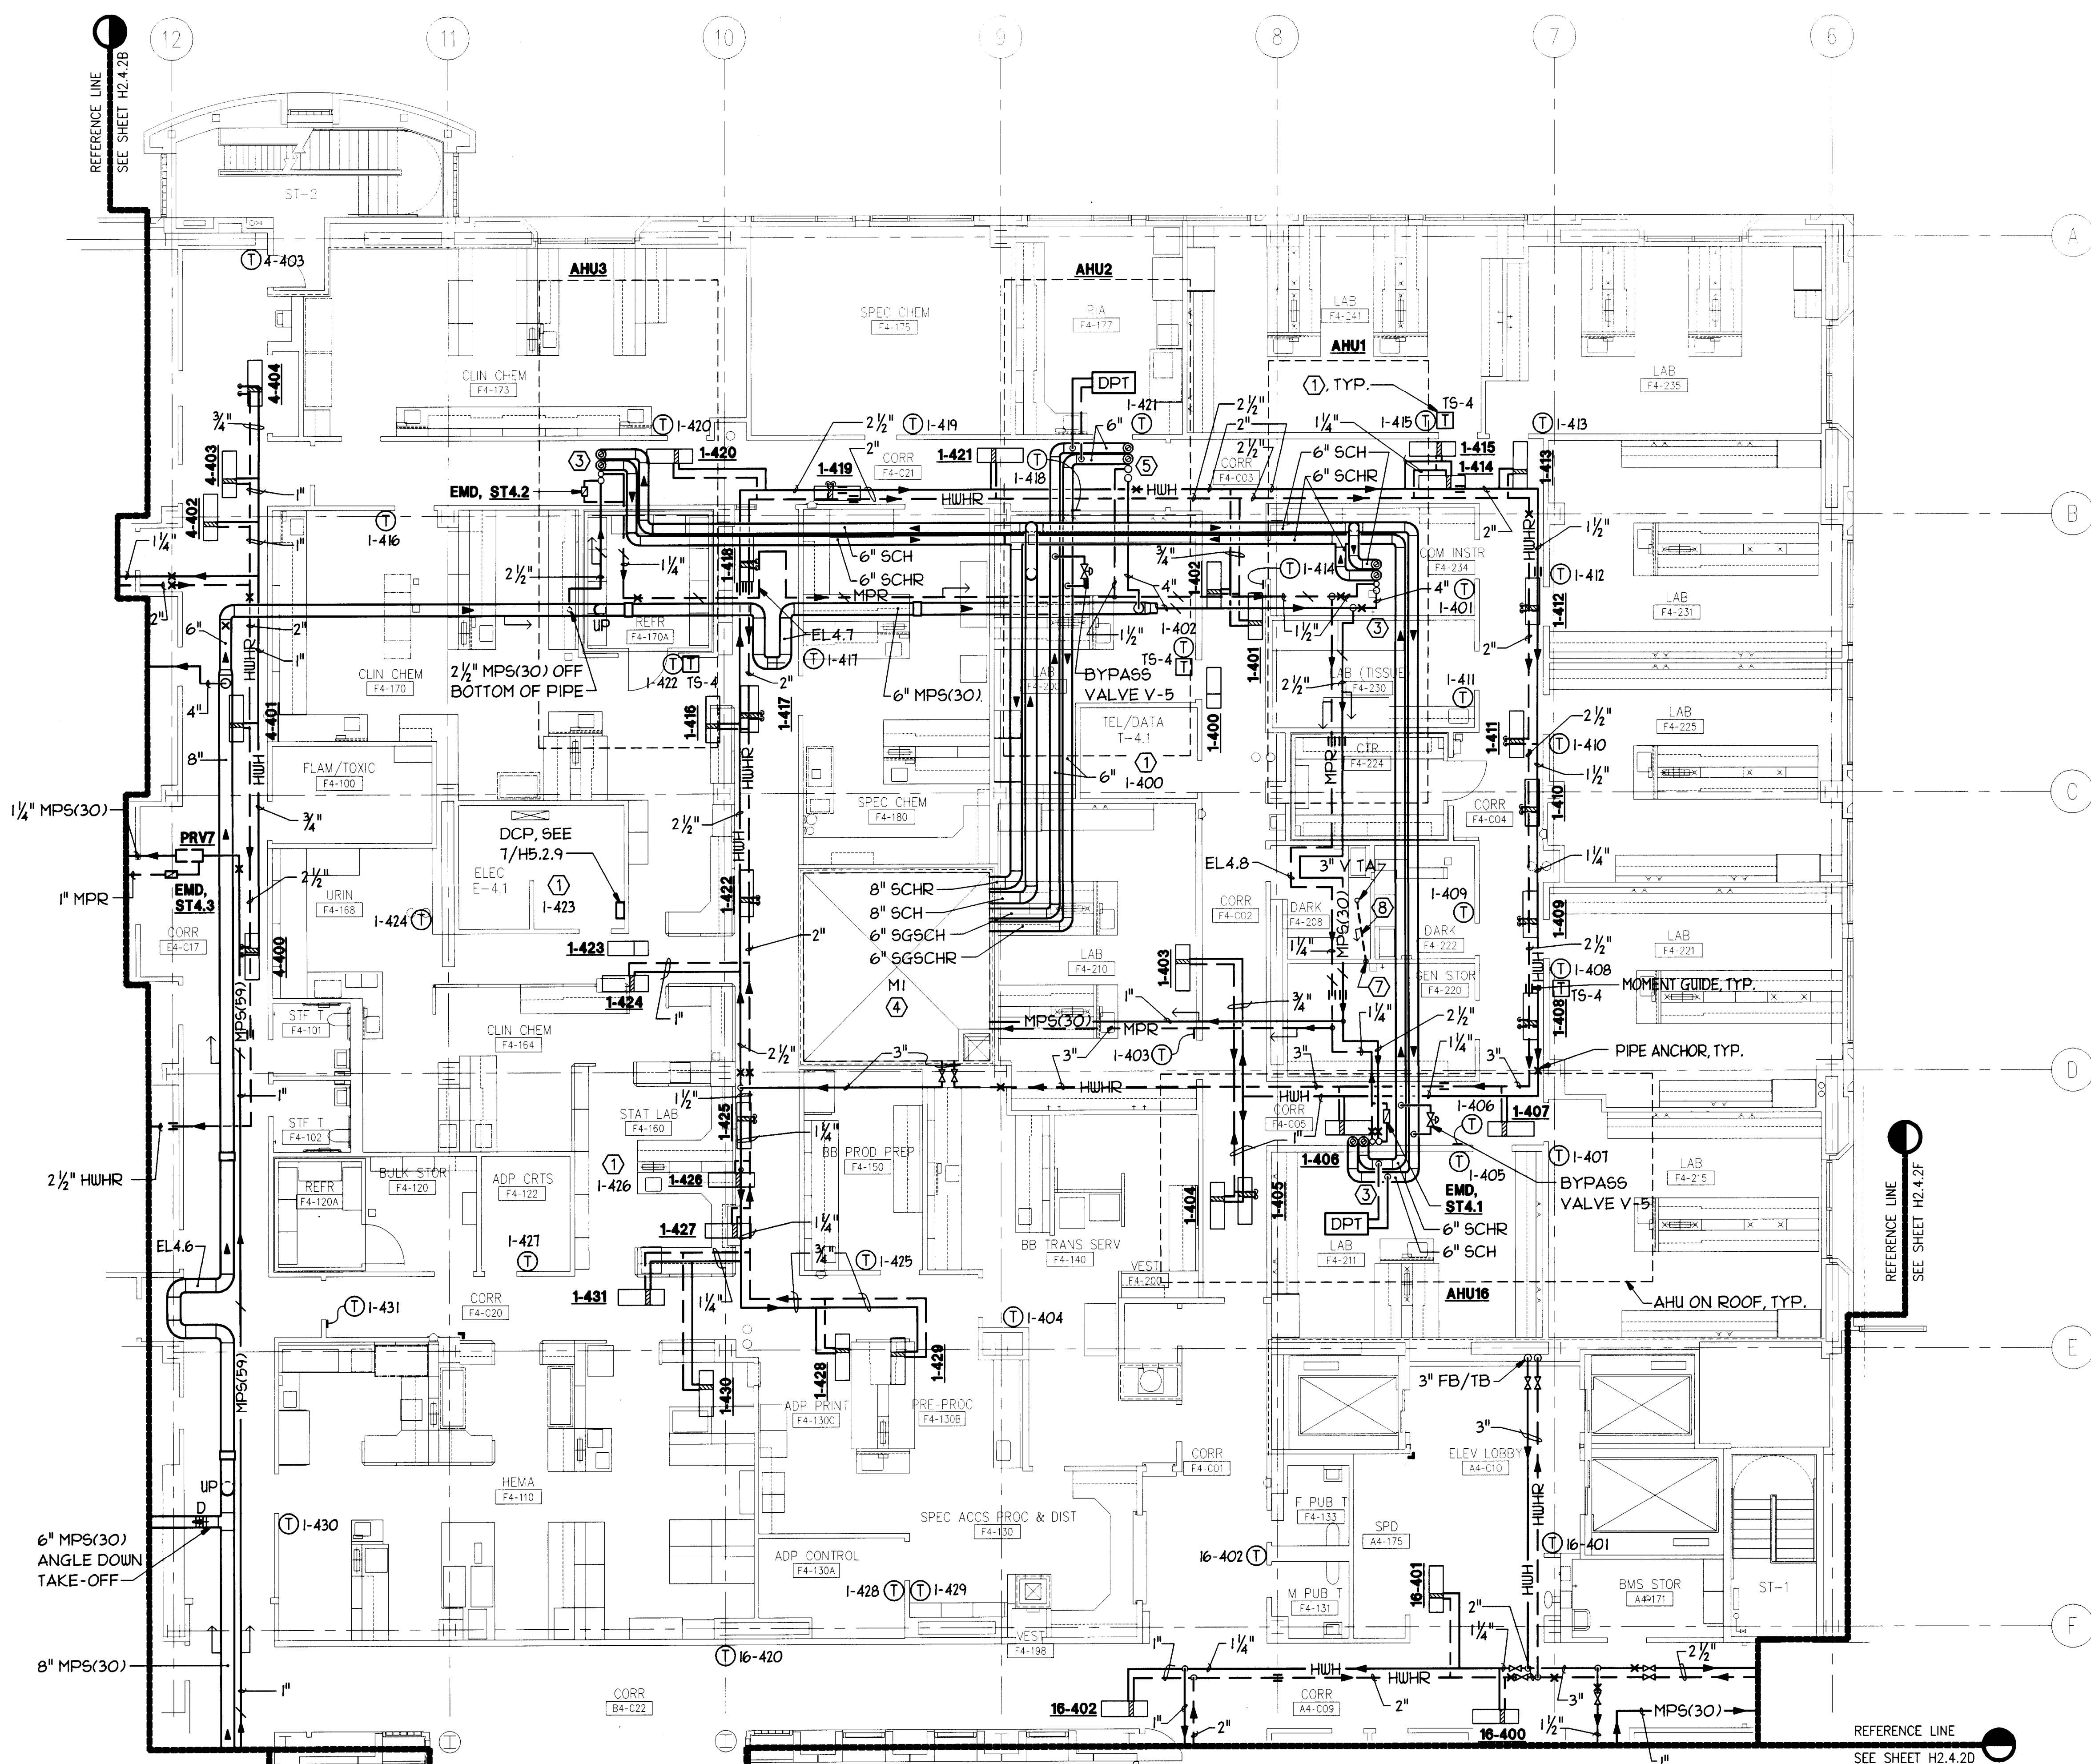

"FOR BASIC FIRE PROTECTION DIAGRAMS, SEE FIRE PROTECTION PLANS, FP PREFIX DRAWINGS. FOR SPECIFIC PARTITION TYPES SEE ARCHITECTURAL DIMENSION PLANS."