



three eighths inch = one foot
one and one-half inches = one foot
one inch = one foot
three-quarters inch = one foot
one-half inch = one foot
one-quarter inch = one foot
one-eighth inch = one foot

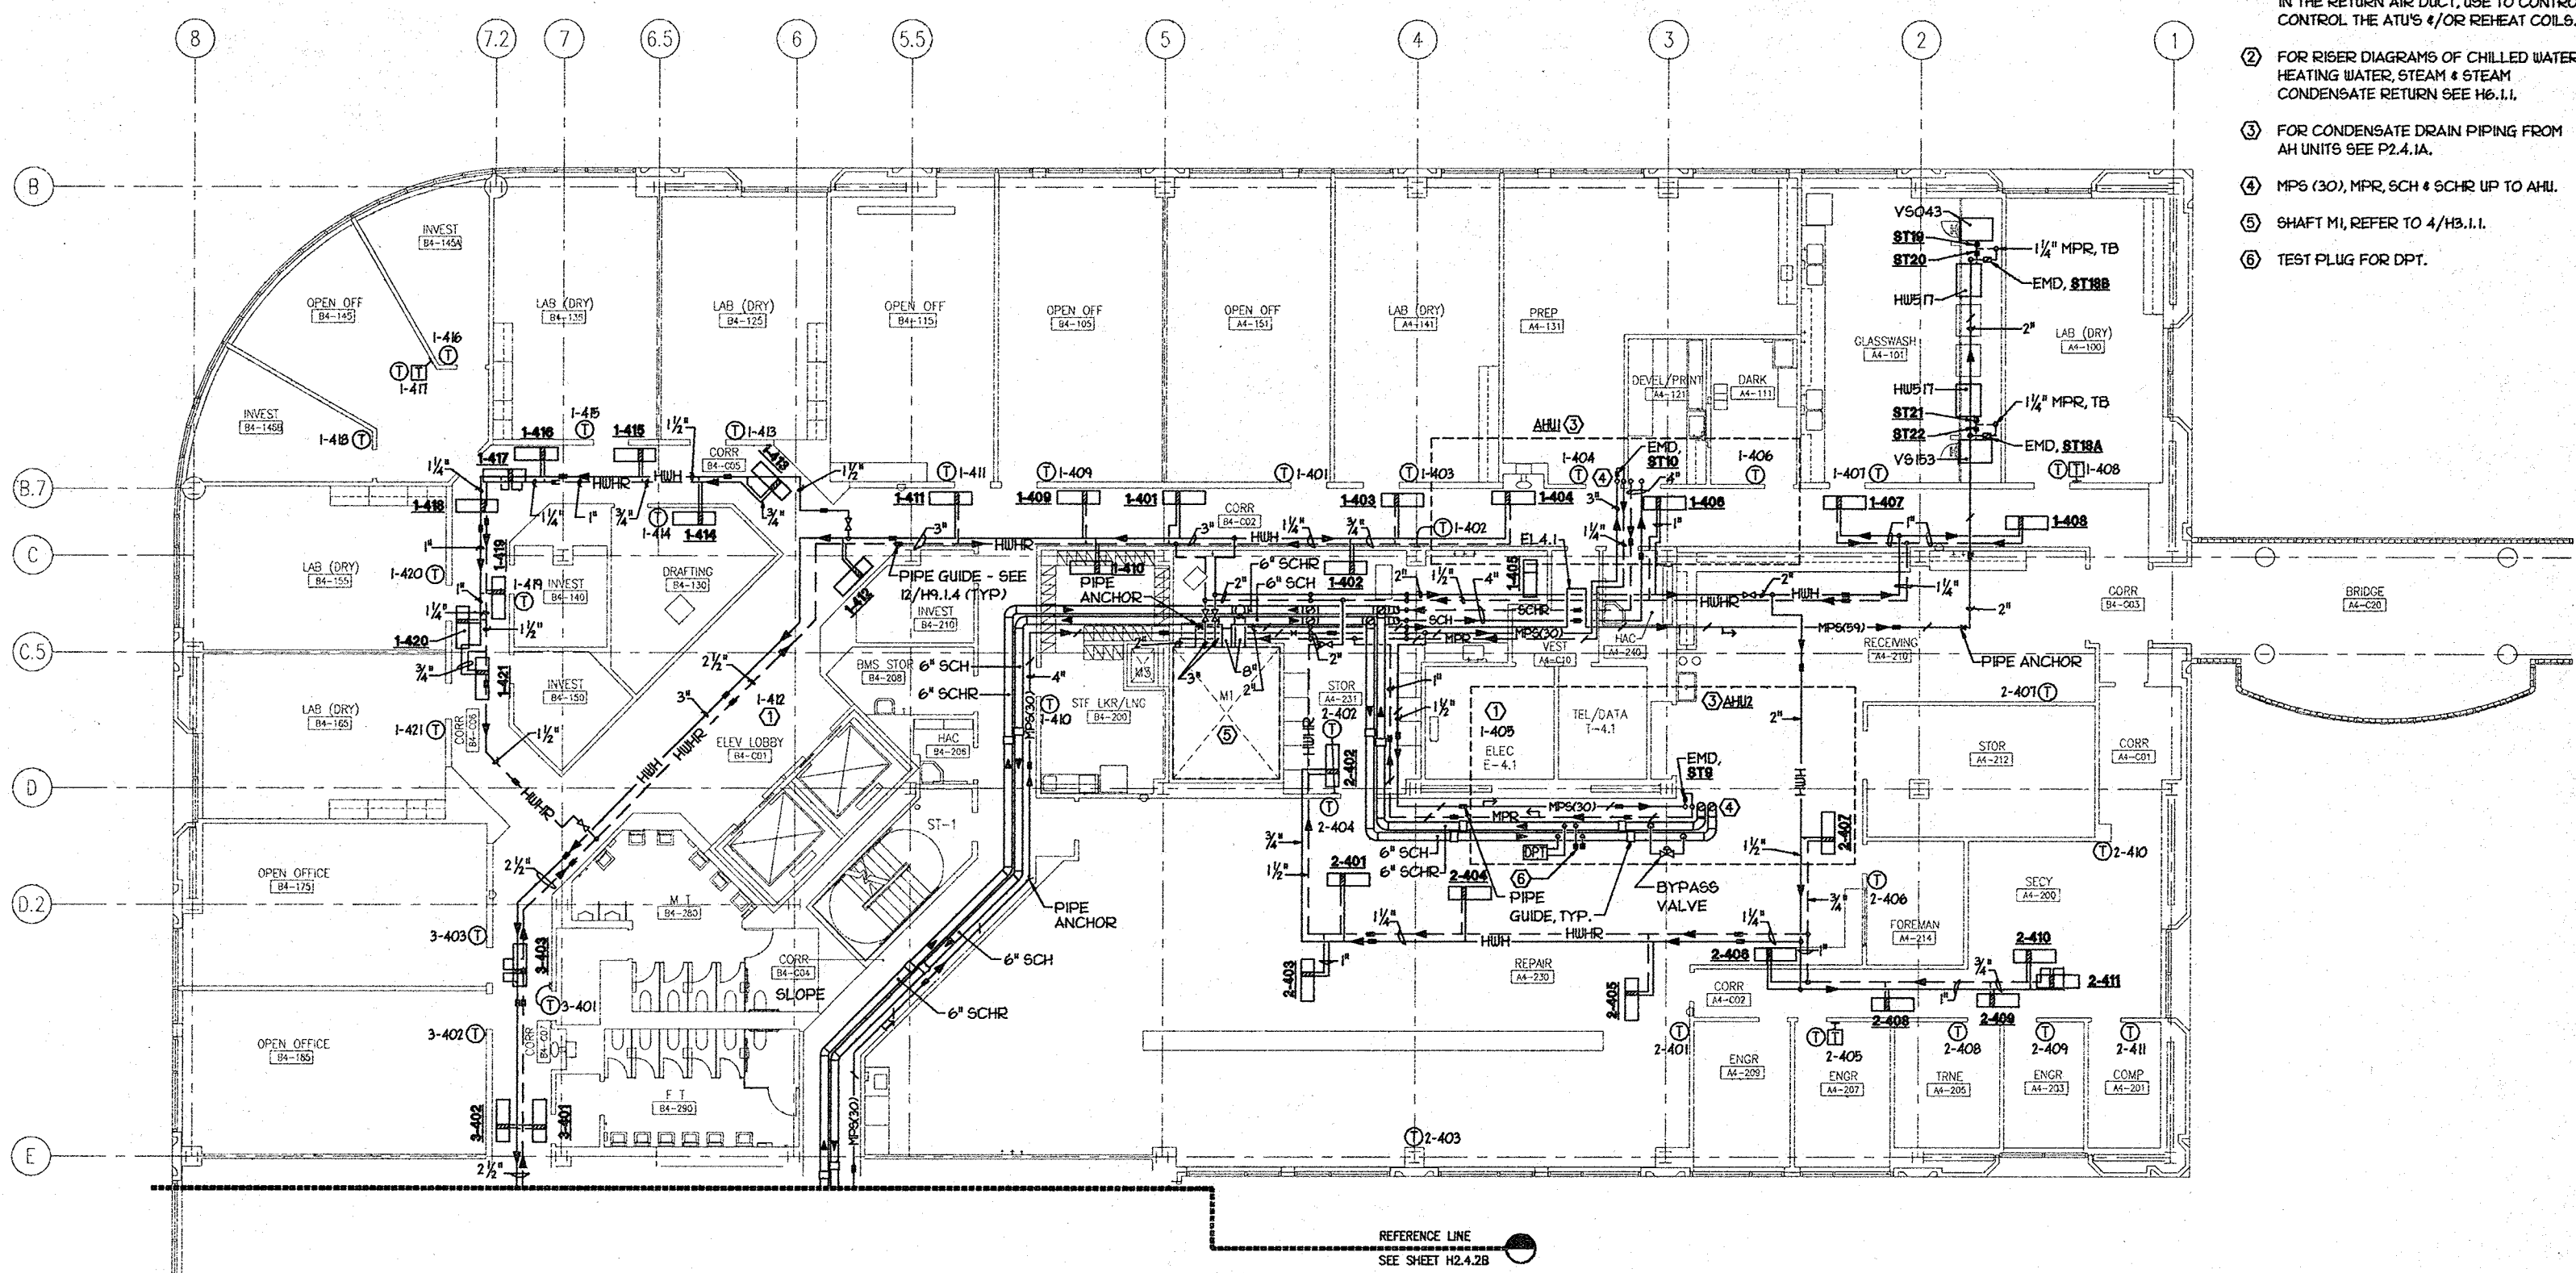

- SHEET NOTES:**
1. INSTALL A TEMPERATURE SENSOR (DDC) IN THE RETURN AIR DUCT, USE TO CONTROL THE AHU'S &/OR REHEAT COILS.
 2. FOR RISER DIAGRAMS OF CHILLED WATER, HEATING WATER, STEAM & STEAM CONDENSATE RETURN SEE H6.1.1.
 3. FOR CONDENSATE DRAIN PIPING FROM AH UNITS SEE P2.4.1A.
 4. MPS (30), MPR, SCH & SCHR UP TO AHU.
 5. SHAFT M1, REFER TO 4/H3.1.1.
 6. TEST PLUG FOR DPT.

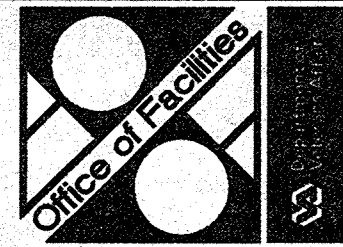



Yoon C. Aglin
Western Team Director

Approved Project Director

ARCHITECT
The Ratcliff Architects
5856 Doyle Street
Emeryville, CA 94608
P.O. Box 1022
Berkeley, CA 94701
(510) 852-1972

ASSOCIATE ARCHITECT
Stone, Marracini and Patterson
One Market Plaza
Spear Street Tower, Suite 400
San Francisco, CA 94105
(415) 227-0100

CONSULTANTS
Structural Engineers
H.J. Degnan & Associates
Mechanical Engineers
Capital Engineering Consultants, Inc.
Electrical Engineers
The Engineering Enterprise
Cost Estimator
Adams Associates
Landscape Design/
Land Planning
Ort Land Associates, Inc.
Civil Engineer
Sundt and Associates, Inc.
Elevator Consultant
Syka and Hennessy
Fire Protection
Rolf Jensen and Associates
Food Service Consultant
Cini-Little International, Inc.

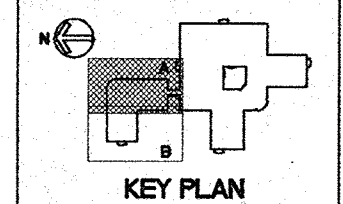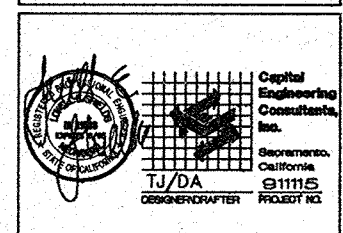

Revisions	Date

Location VA Medical Center
Palo Alto, CA

Project Title
REPLACE CLINICAL/
BED TOWER FOR
SEISMIC CORRECTIONS

FULLY SPRINKLERED

TRA Project No.	Checked	Drawn
93007	TGJ	DA

Drawing Title
FOURTH FLOOR
PLAN, AREA A -
PIPING

Scale 1/8" = 1'-0"

VA Project No. 640-042G Building Number 101

Date 2 MAY 1994 Drawing No. H2.4.2A

"FOR BASIC FIRE PROTECTION DIAGRAM, SEE FIRE PROTECTION PLANS, FP PREFIX DRAWINGS. FOR SPECIFIC PARTITION TYPES SEE ARCHITECTURAL DIMENSION PLANS."