

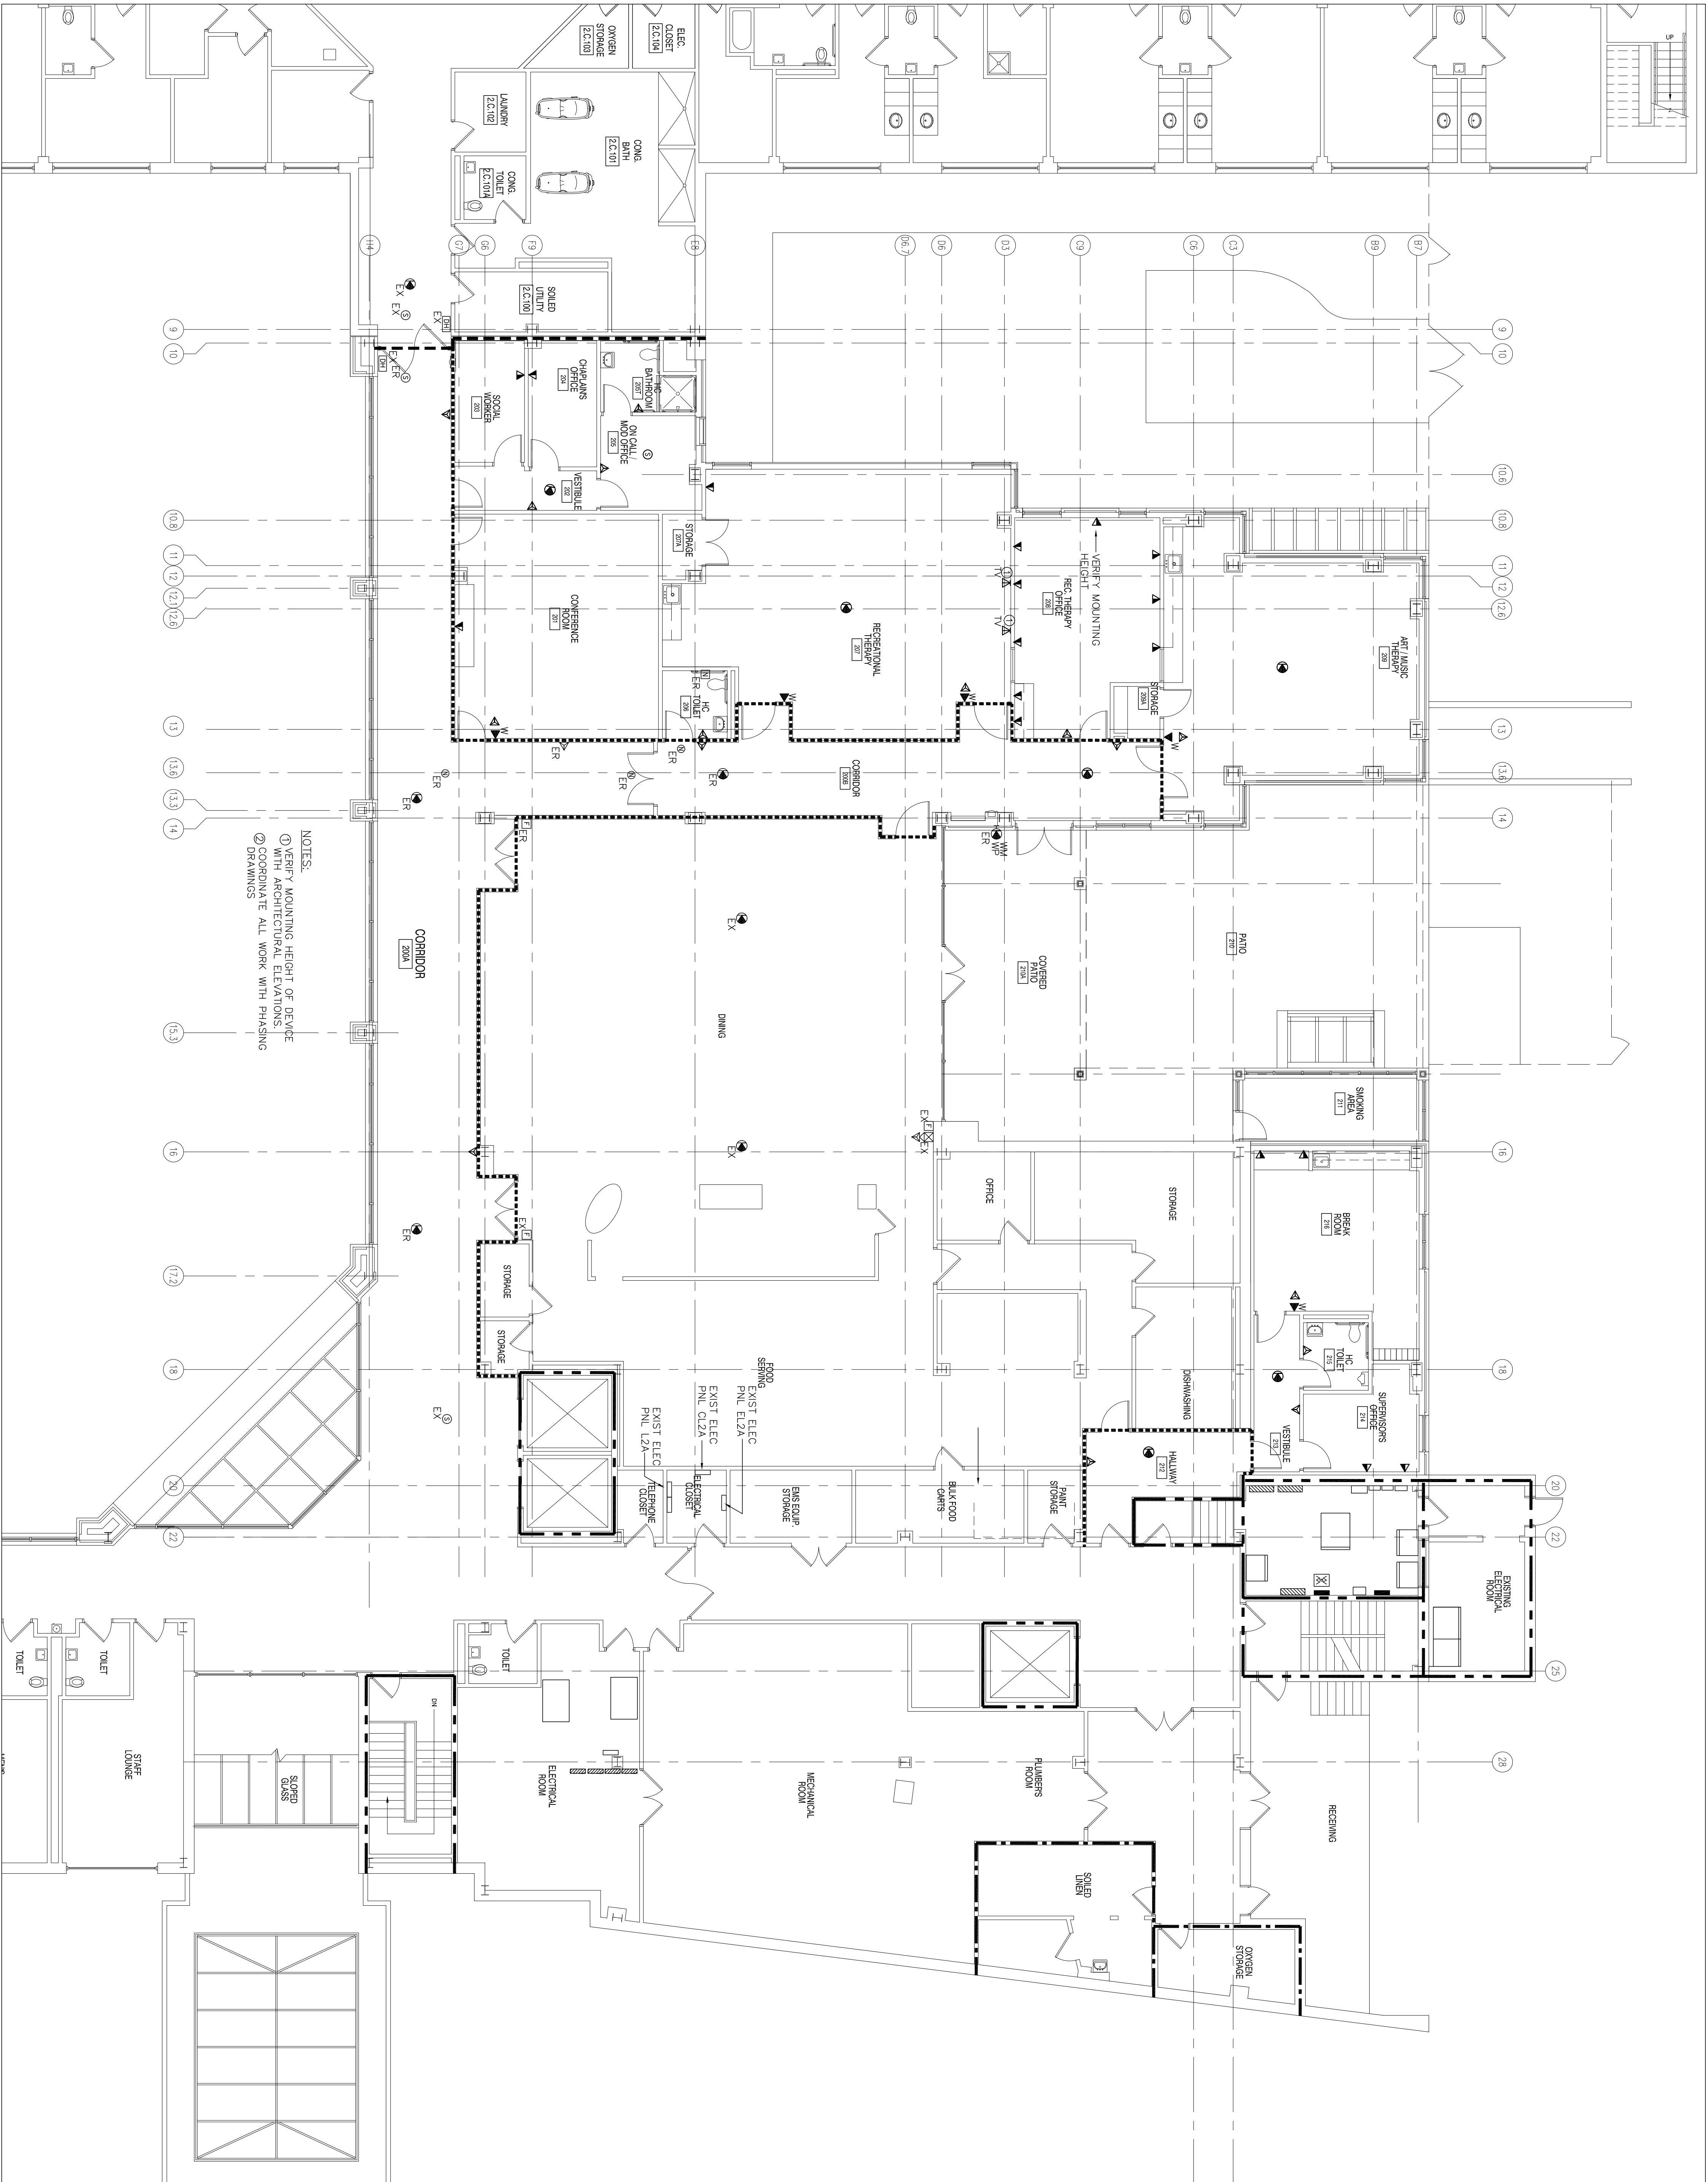


PARTITION LEGEND	
---	SHORE PARTITION, PRESENT
---	SHORE PARTITION, NEW
---	SHORE BARBER, 1 HR RATING
---	2 HR RATED PARTITION
---	1 HR RATED PARTITION

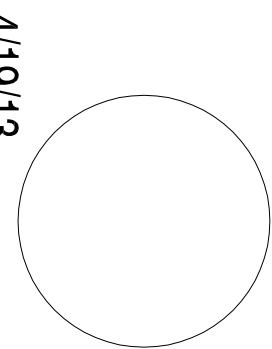

2ND FLOOR PLAN
1/8" = 1'-0"

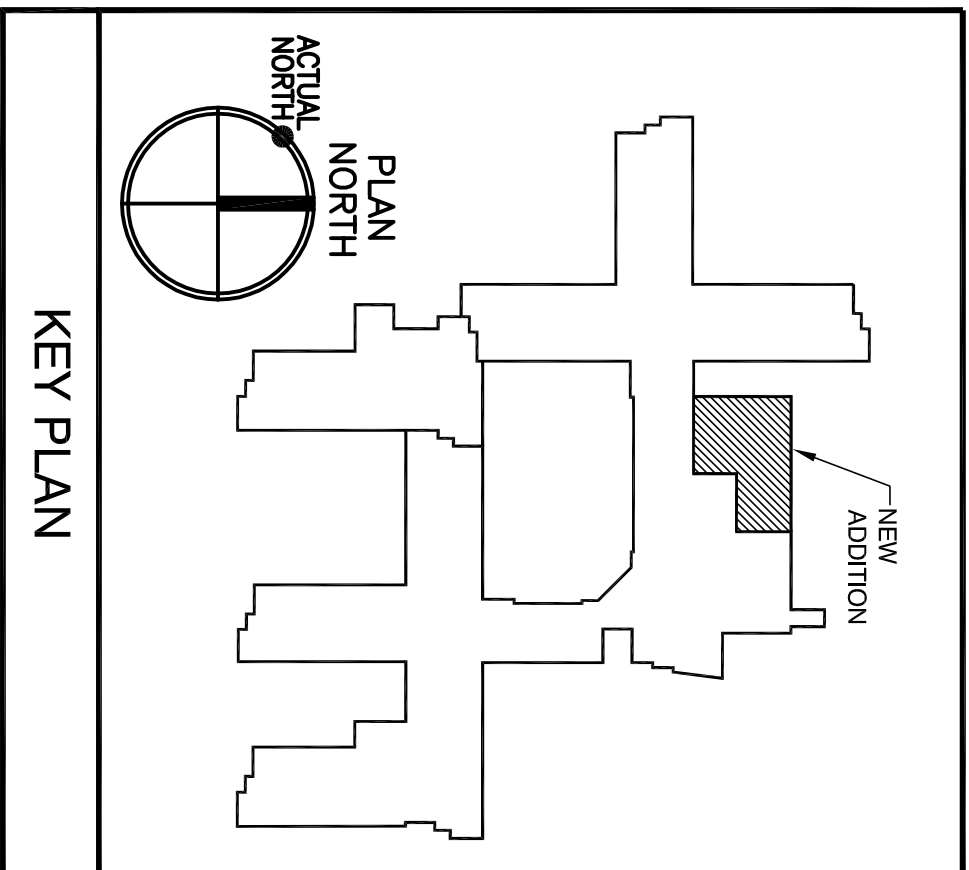

Revisions		Date	
<div><div></div><div><div>Department of Veterans Affairs</div><div>New Jersey Health Care System</div><div>151 Knollcroft Road</div><div>Lyons, New Jersey 07939</div></div></div>			
<div><div></div><div>BBLM Architects</div></div>		<div><div></div><div>Piller & Borge Associates, LLC</div><div>4220 Main Street</div><div>Philadelphia, PA 19127</div><div>T: (215) 506-5000</div><div>F: (215) 506-5000</div></div>	
<div><div></div><div>The Karpis Group</div><div>1218 Chestnut Street</div><div>Philadelphia, PA 19107</div><div>T: (215) 288-1994</div><div>F: (215) 288-8980</div></div>		<div><div></div><div>LKU CONSULTING ENGINEERS</div><div>241 WILSON DRIVE</div><div>BRIMWOOD PARK, NJ 07007</div><div>Phone: (201) 751-1210</div><div>Mobile: (201) 751-1210</div><div>Engineer NJ NO 28343</div></div>	
Drawing Title ELECTRICAL: SECOND FLOOR - SIGNAL		Project Title CLC SUPPORT SPACES VAMC - LYONS	
Approved Chief, Facilities Engineering Serv.		Drawn SMR	
Approved Chief Executive Officer		Checked JA	
Location LYONS, NJ		Building Number 135	
Date 2/05/13		Contact Number 561-CSI-136	
Project No. 1009		Date E-9	
VETERANS ADMINISTRATION		Date OF	