




1 DOWNLIGHT MOUNTING – GYPBOARD CEILING
NTS

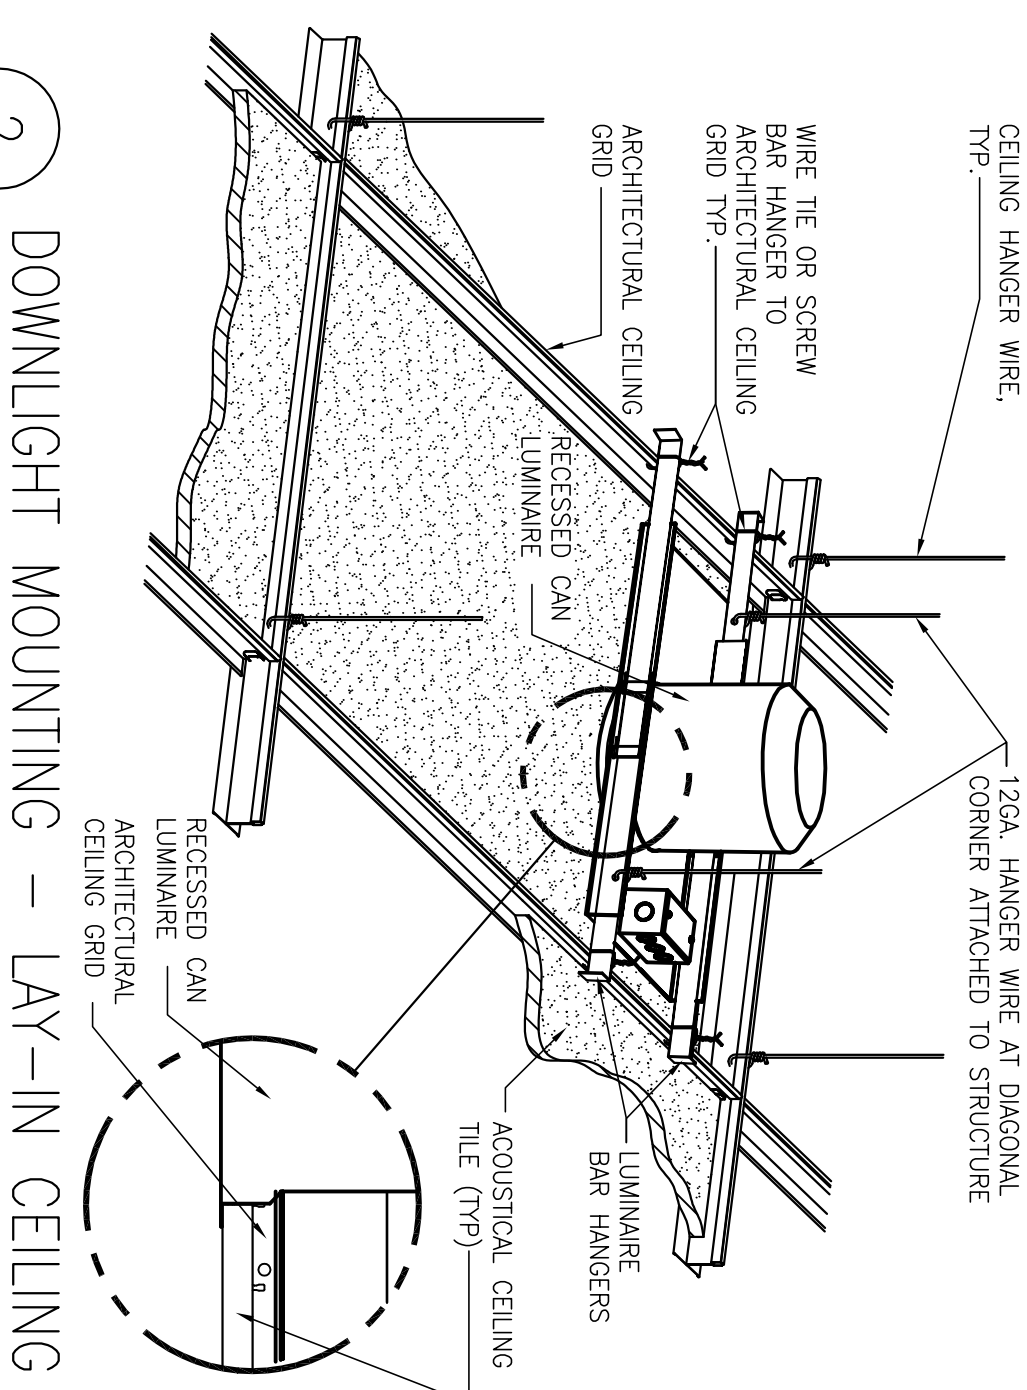


2 DOWNLIGHT MOUNTING – LAY-IN CEILING

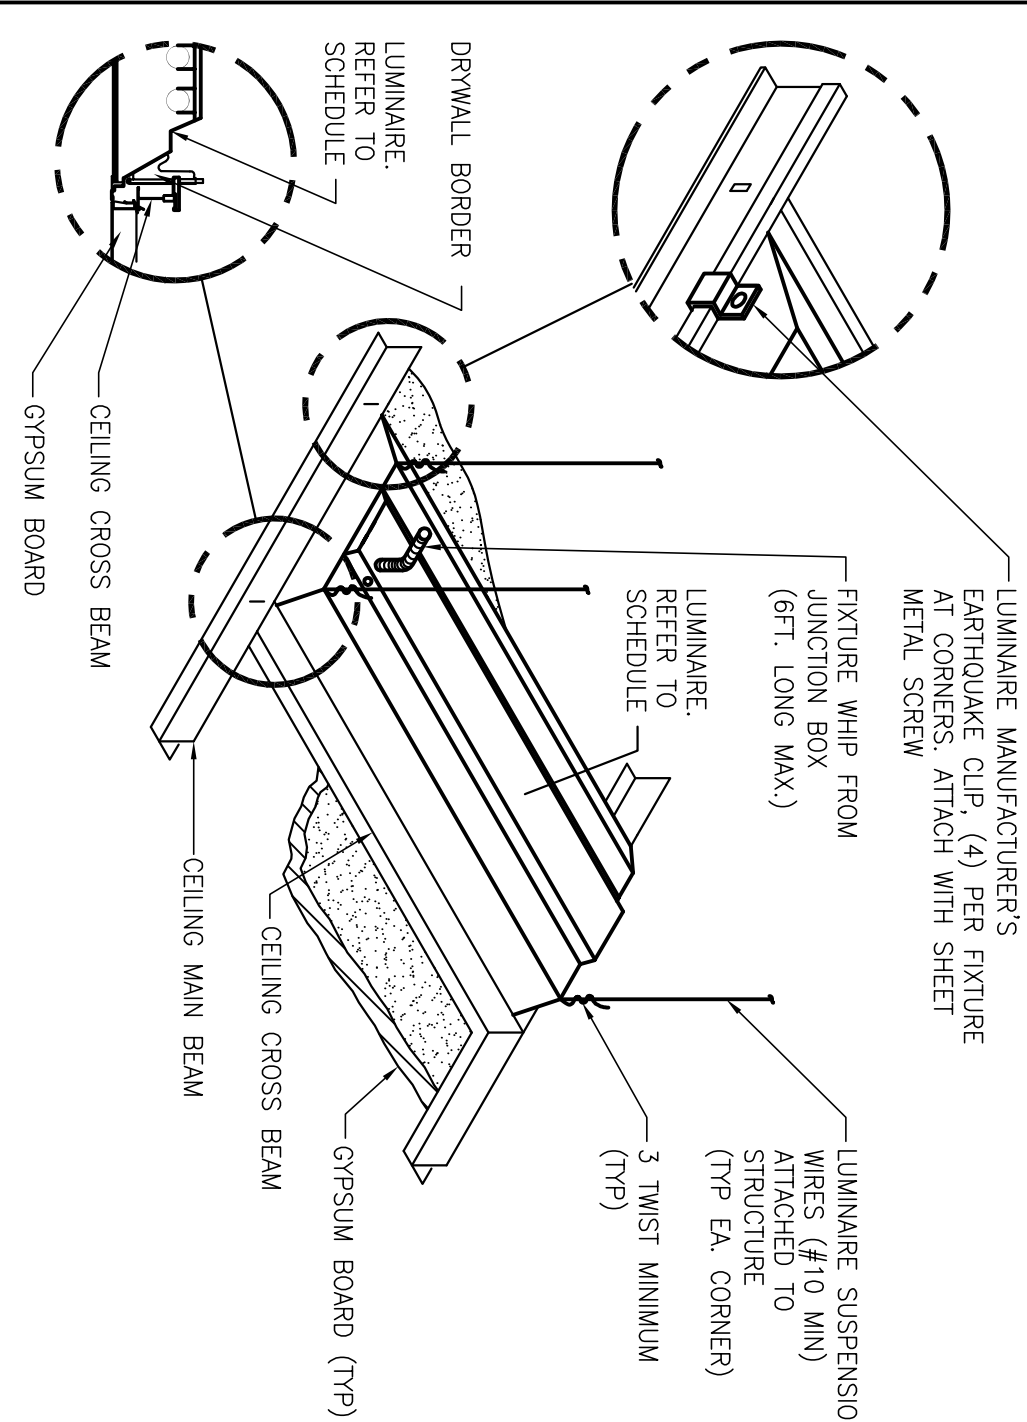


3 LUMINAIRE MOUNTING – GYPBOARD CEILING

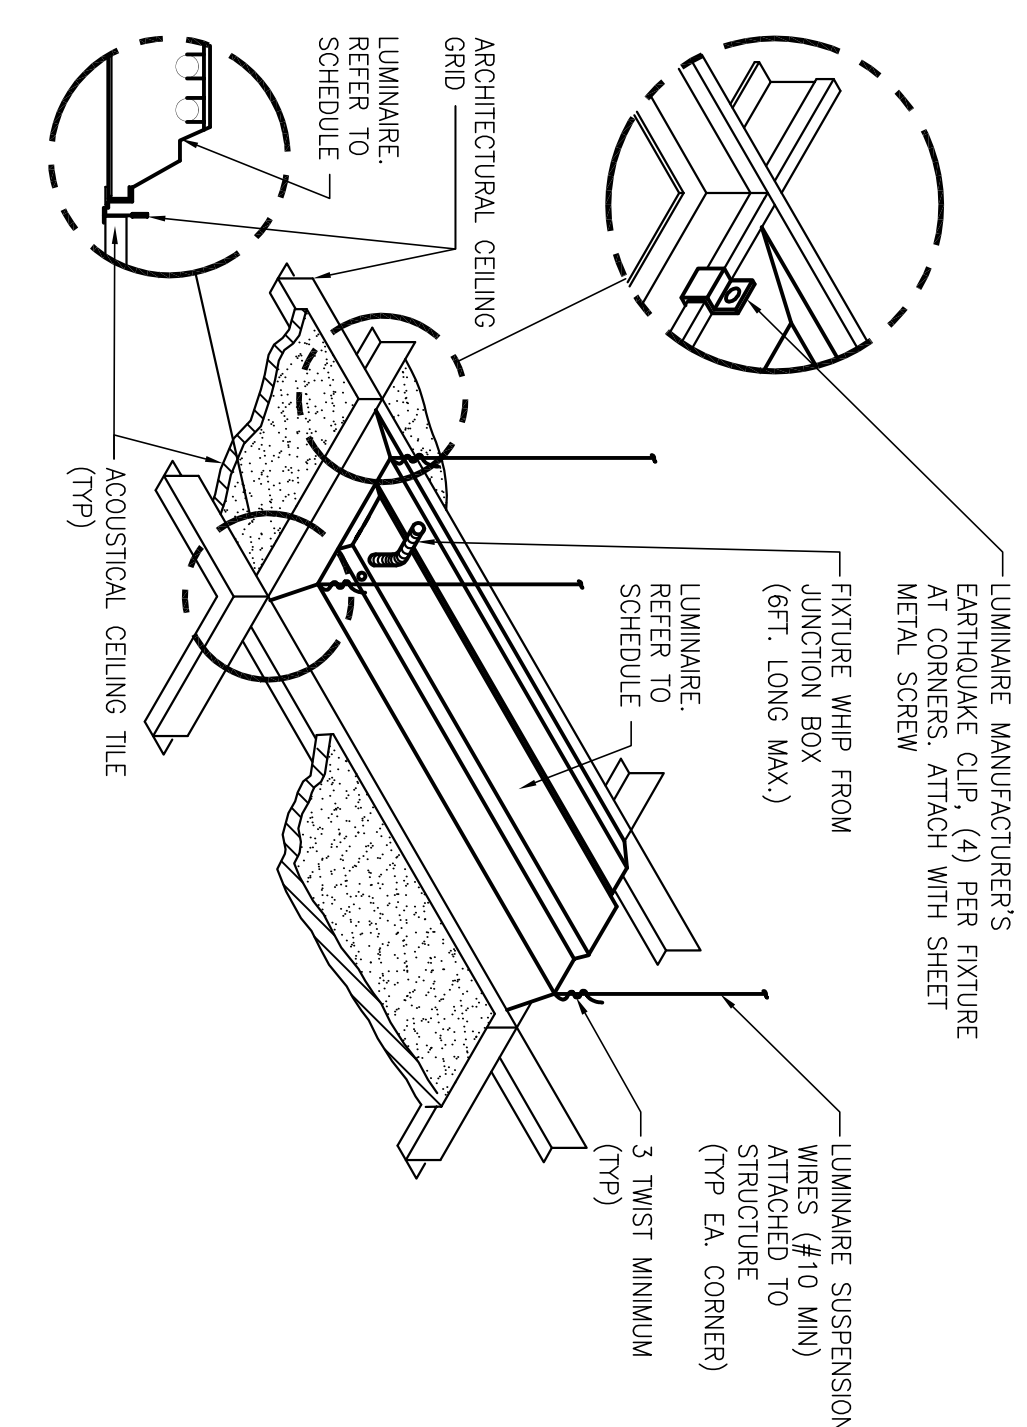


4 LUMINAIRE MOUNTING - LAY-IN CEILING

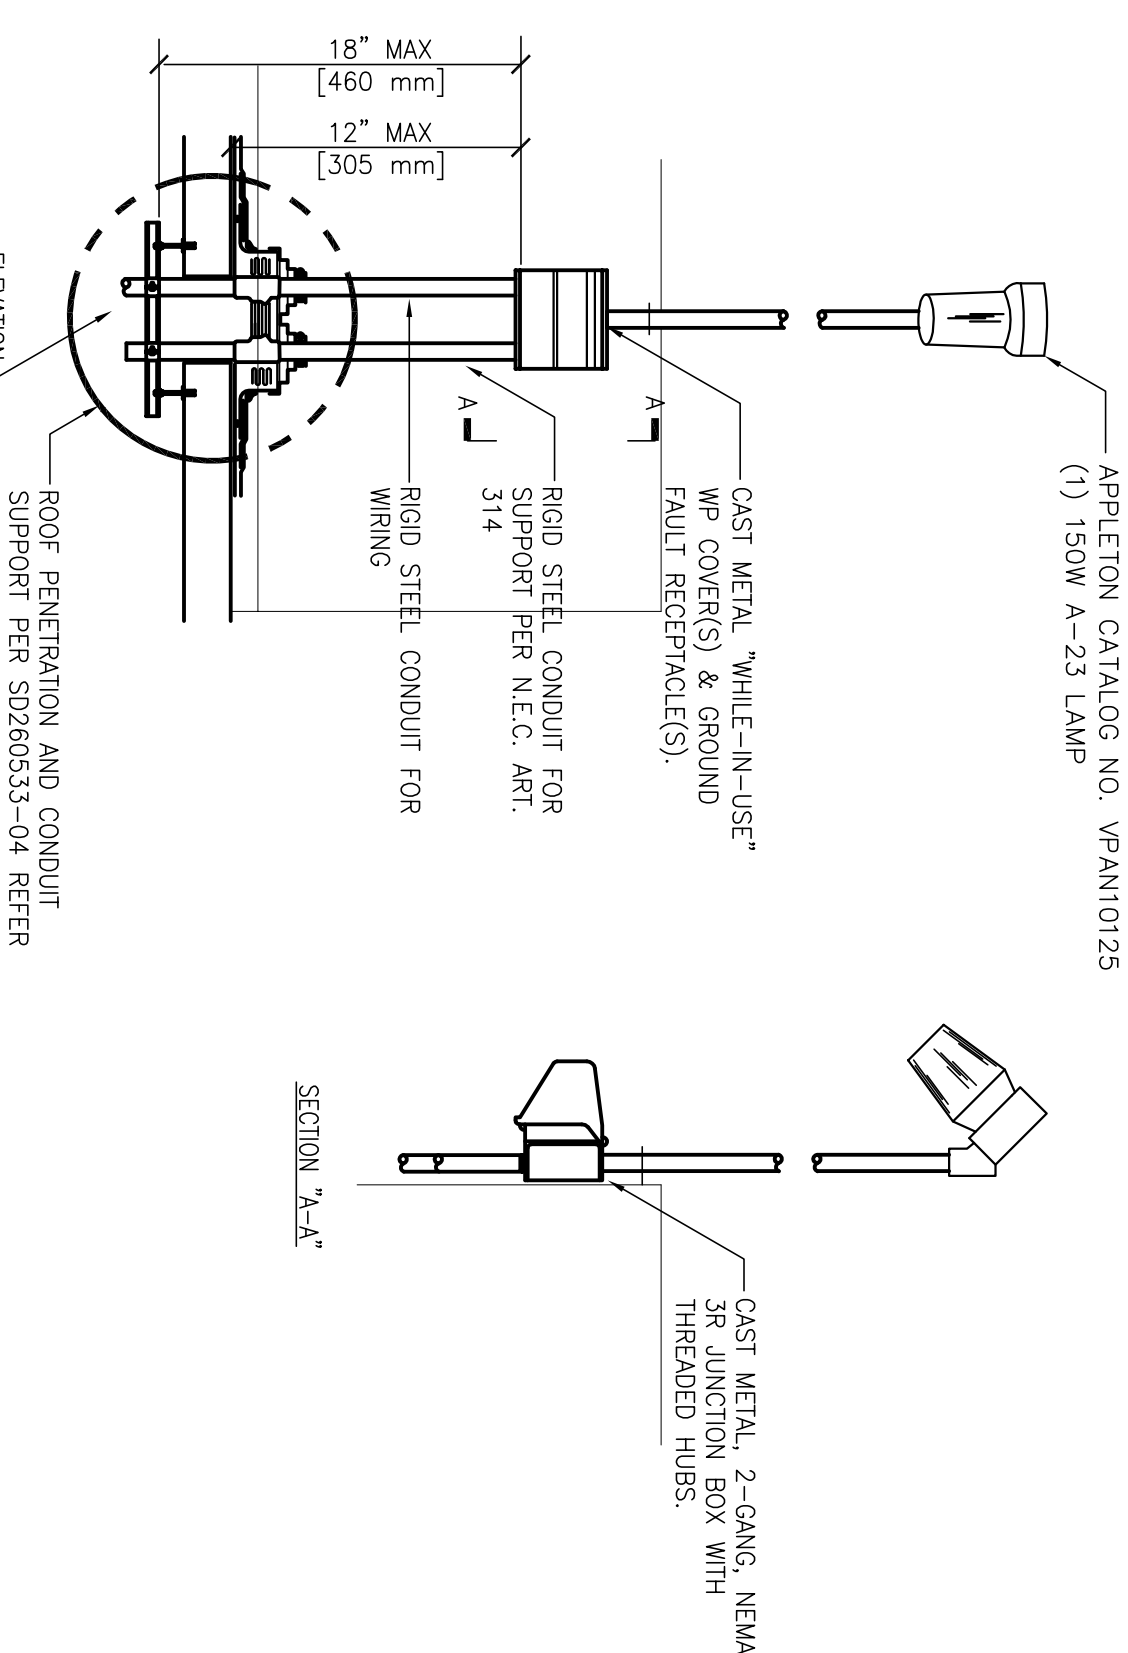


5 ROOFTOP LIGHT FIXTURE/RECEPTACLE MOUNTING DETAIL
NTS

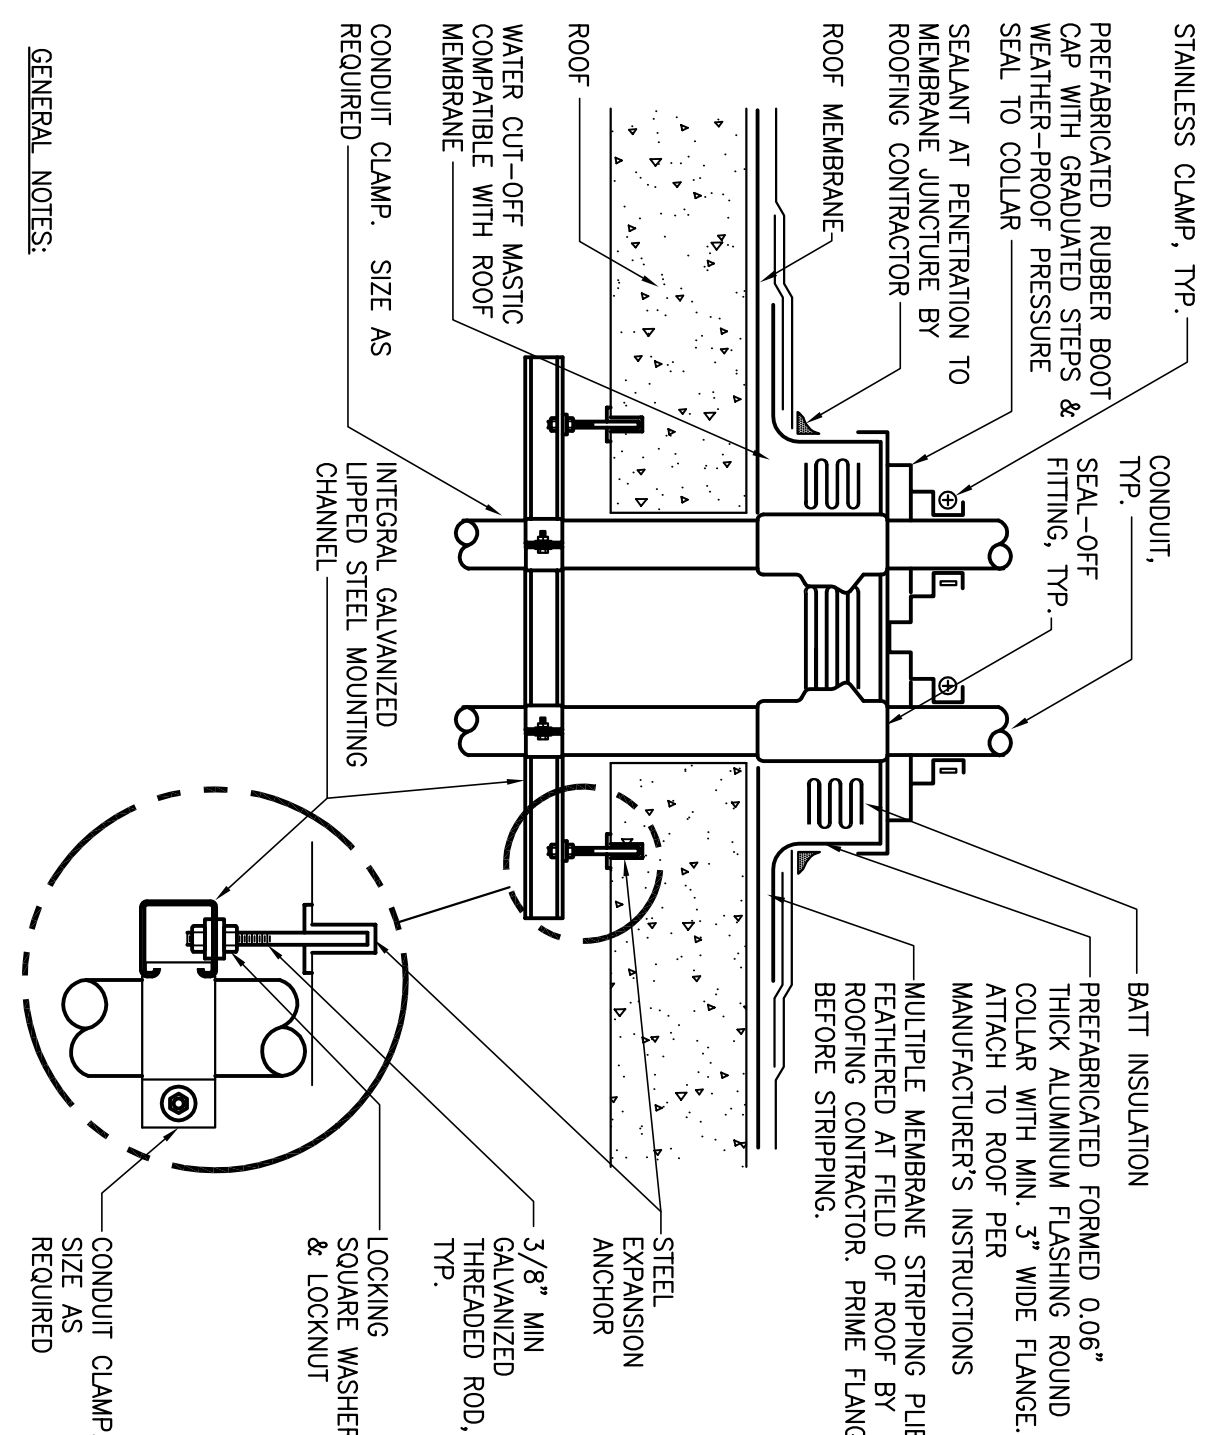

7
NTS
ROOF PENETRATION DETAIL

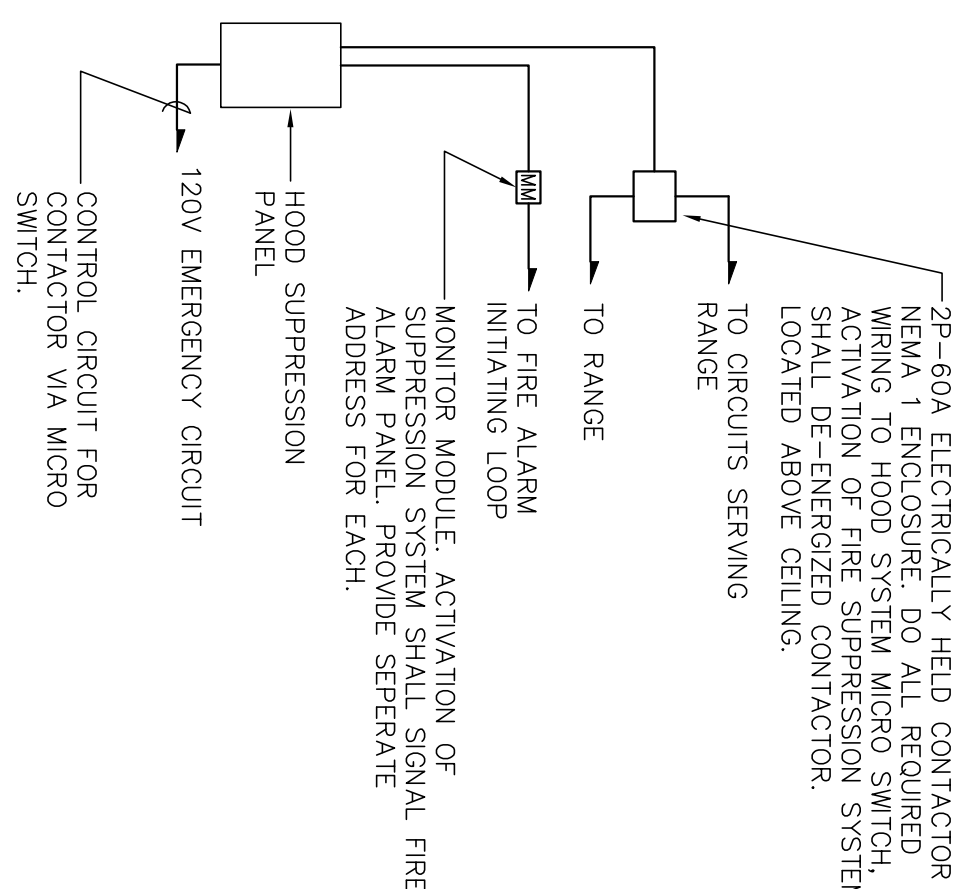


8 FIRE SUPPRESSION SYSTEM WIRING DIAGRAM
NTS

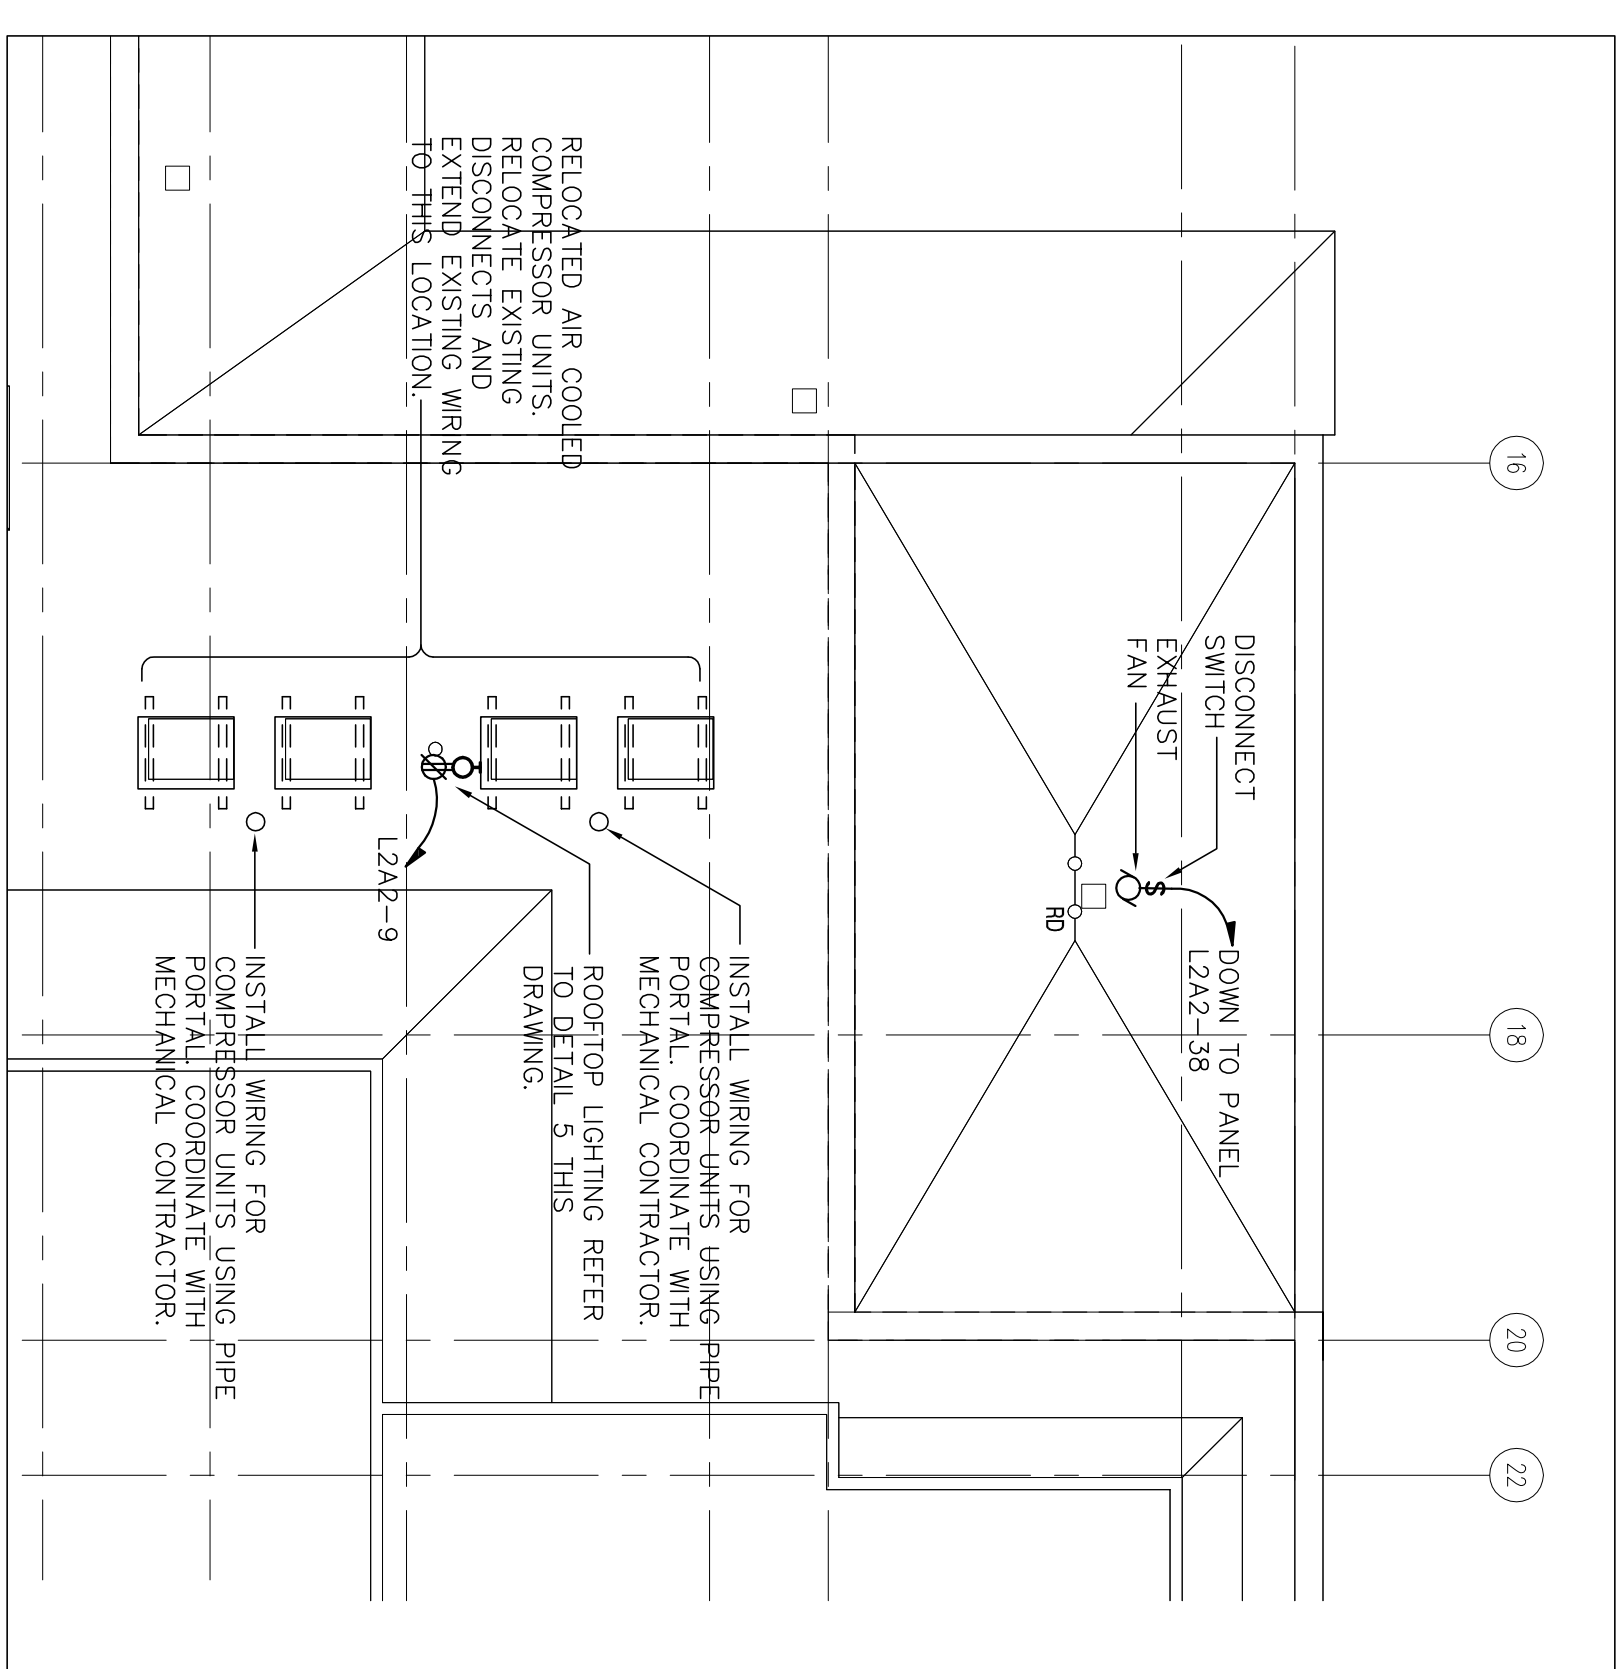

PARTIAL ROOF PLAN
1/8" = 1'-0"

NOTE
SWITCH PLATES SHALL BE LABELED "ROOFTOP
LIGHT" USING LAMACOID LABEL.

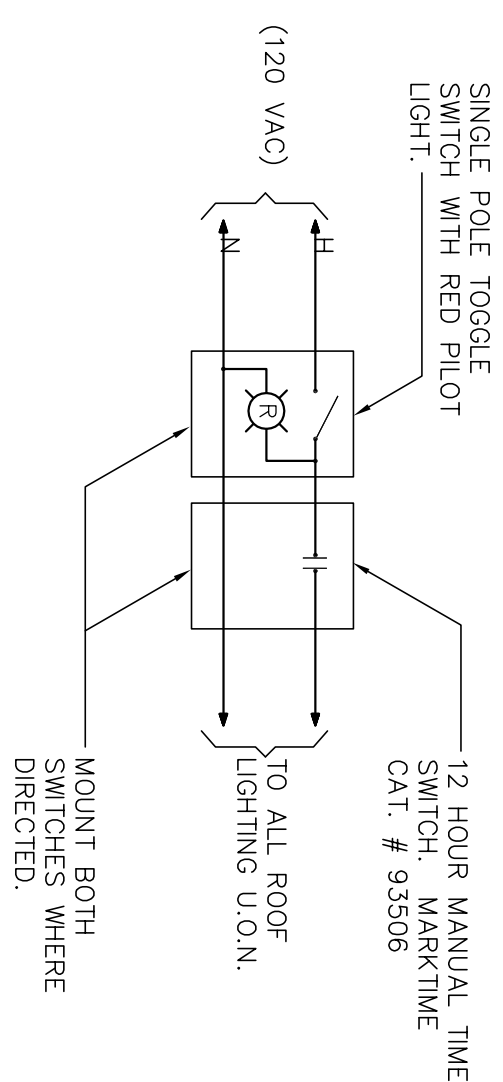

6 CONTROL WIRING DIAGRAM FOR
ROOFTOP LIGHT FIXTURE
MIS

OVERALL FLOOR PLAN		Department of Veterans Affairs New Jersey Health Care System 151 Knollcroft Road Lyons, New Jersey 07939	
Architects Planning Interiors Architecture 824 Cherry Street Phila., PA 1907 (415) 625-2400		Piner & Piner Associates, LLC 4220 Main Street Philadelphia, PA 19127 E: (215) 506-5800 F: (215) 506-5800	
The Keenan Group 1219 Chestnut Street Philadelphia, PA 19107 E: (215) 238-1884 F: (215) 238-9850		CONSULTING ENGINEERS TKU GROUP INC. CHRYSLER INC.	
Approved: Chief Facilities Engineering Serv.		Drawing Title ELECTRICAL: MISCELLANEOUS DETAILS	
Approved: Chief Executive Officer		Project Title CLC SUPPORT SPACES VAMC - LYONS	
Drawn SMR		Building Number 135	
Checked JA		Contact Number 561-CSJ-136	
Location LYONS, NJ		Project No. 1009	
Date 05-11		Drawing No. E-11	
VETERANS ADMINISTRATION			