

2ND FLOOR – ALTERNATES NO.7, 8 AND 9
1/8" = 1'-0"

PARTITION LEGEND


SMOKE PARTITION - PRESENT

NEW ASSIGNED SMOKE

SMOKE DAMPER - 1 HR RATING

2 HR RATED PARTITION

1 HR RATED PARTITION

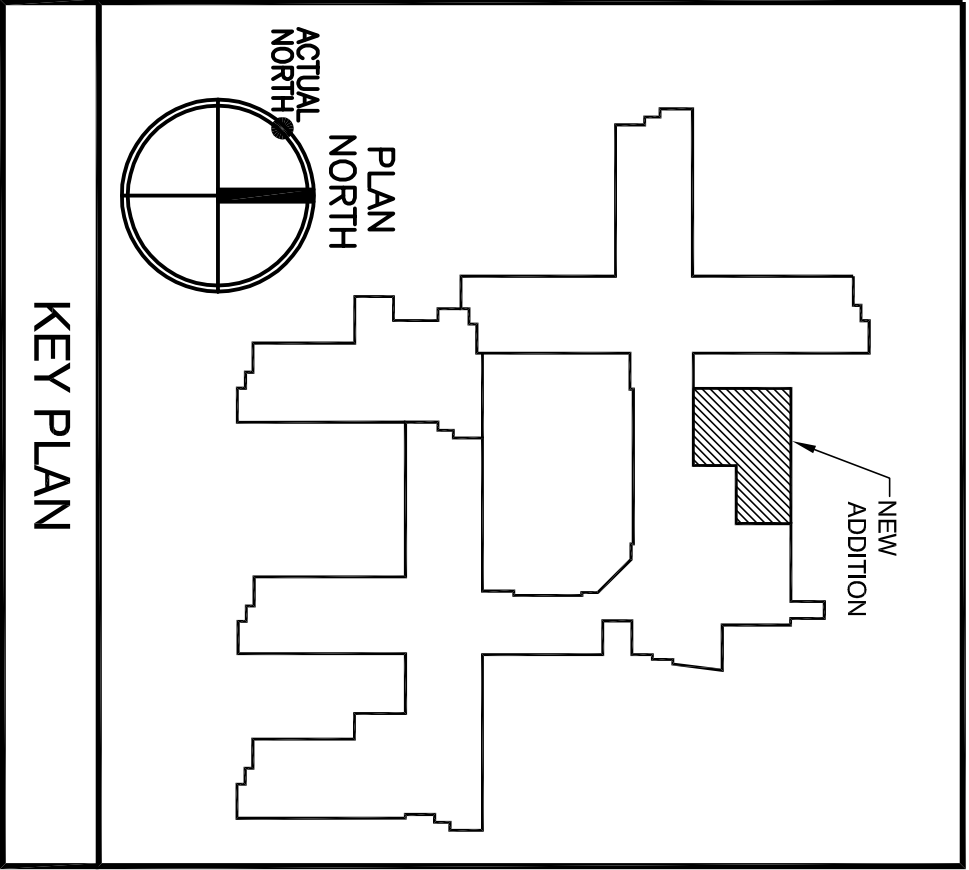

Revisions

Date

OVERALL FLOOR PLAN

Department of Veterans Affairs
New Jersey Health Care System
151 Knollcroft Road
Lyons, New Jersey 07939

BLM
Architects

824 Cherry Street
Phila., PA 19107
(215) 625-2600

Miller & Berne Associates, LLC
4220 Main Street
Philadelphia, PA 19127
T: (215) 908-9900
F: (215) 908-9900

The Karpis Group
1218 Chestnut Street
Philadelphia, PA 19107
T: (215) 289-1994
F: (215) 289-9890

CH2M HILL
CONSULTING ENGINEERS
241 Walnut Drive
Elmwood Park, NJ 07407
T: (201) 793-0200
F: (201) 793-0200
Engineer NJ NO. 28943

Drawing Title
MECHANICAL:
2ND FLOOR – ALTERNATES NO. 7, 8 & 9

Project Title
CLC SUPPORT SPACES
VAMC - LYONS

Date
2/05/13

Project No.
1009

Approved: Chief, Facilities Engineering Serv.

Drawn
SMR

Building Number
135

Contract Number
561-CS1-136

Approved: Chief Executive Officer

Checked
JA

Location
LYONS, NJ

Date
4/19/13

Project No.
M-15

Drawn
OF

VETERANS
ADMINISTRATION