



A
three inches = one foot
B
one and one-half inch = one foot
C
one inch = one foot
D
three-quarters inch = one foot
E
one-half inch = one foot
F
three-eighths inch = one foot
one-quarter inch = one foot
one-eighth inch = one foot

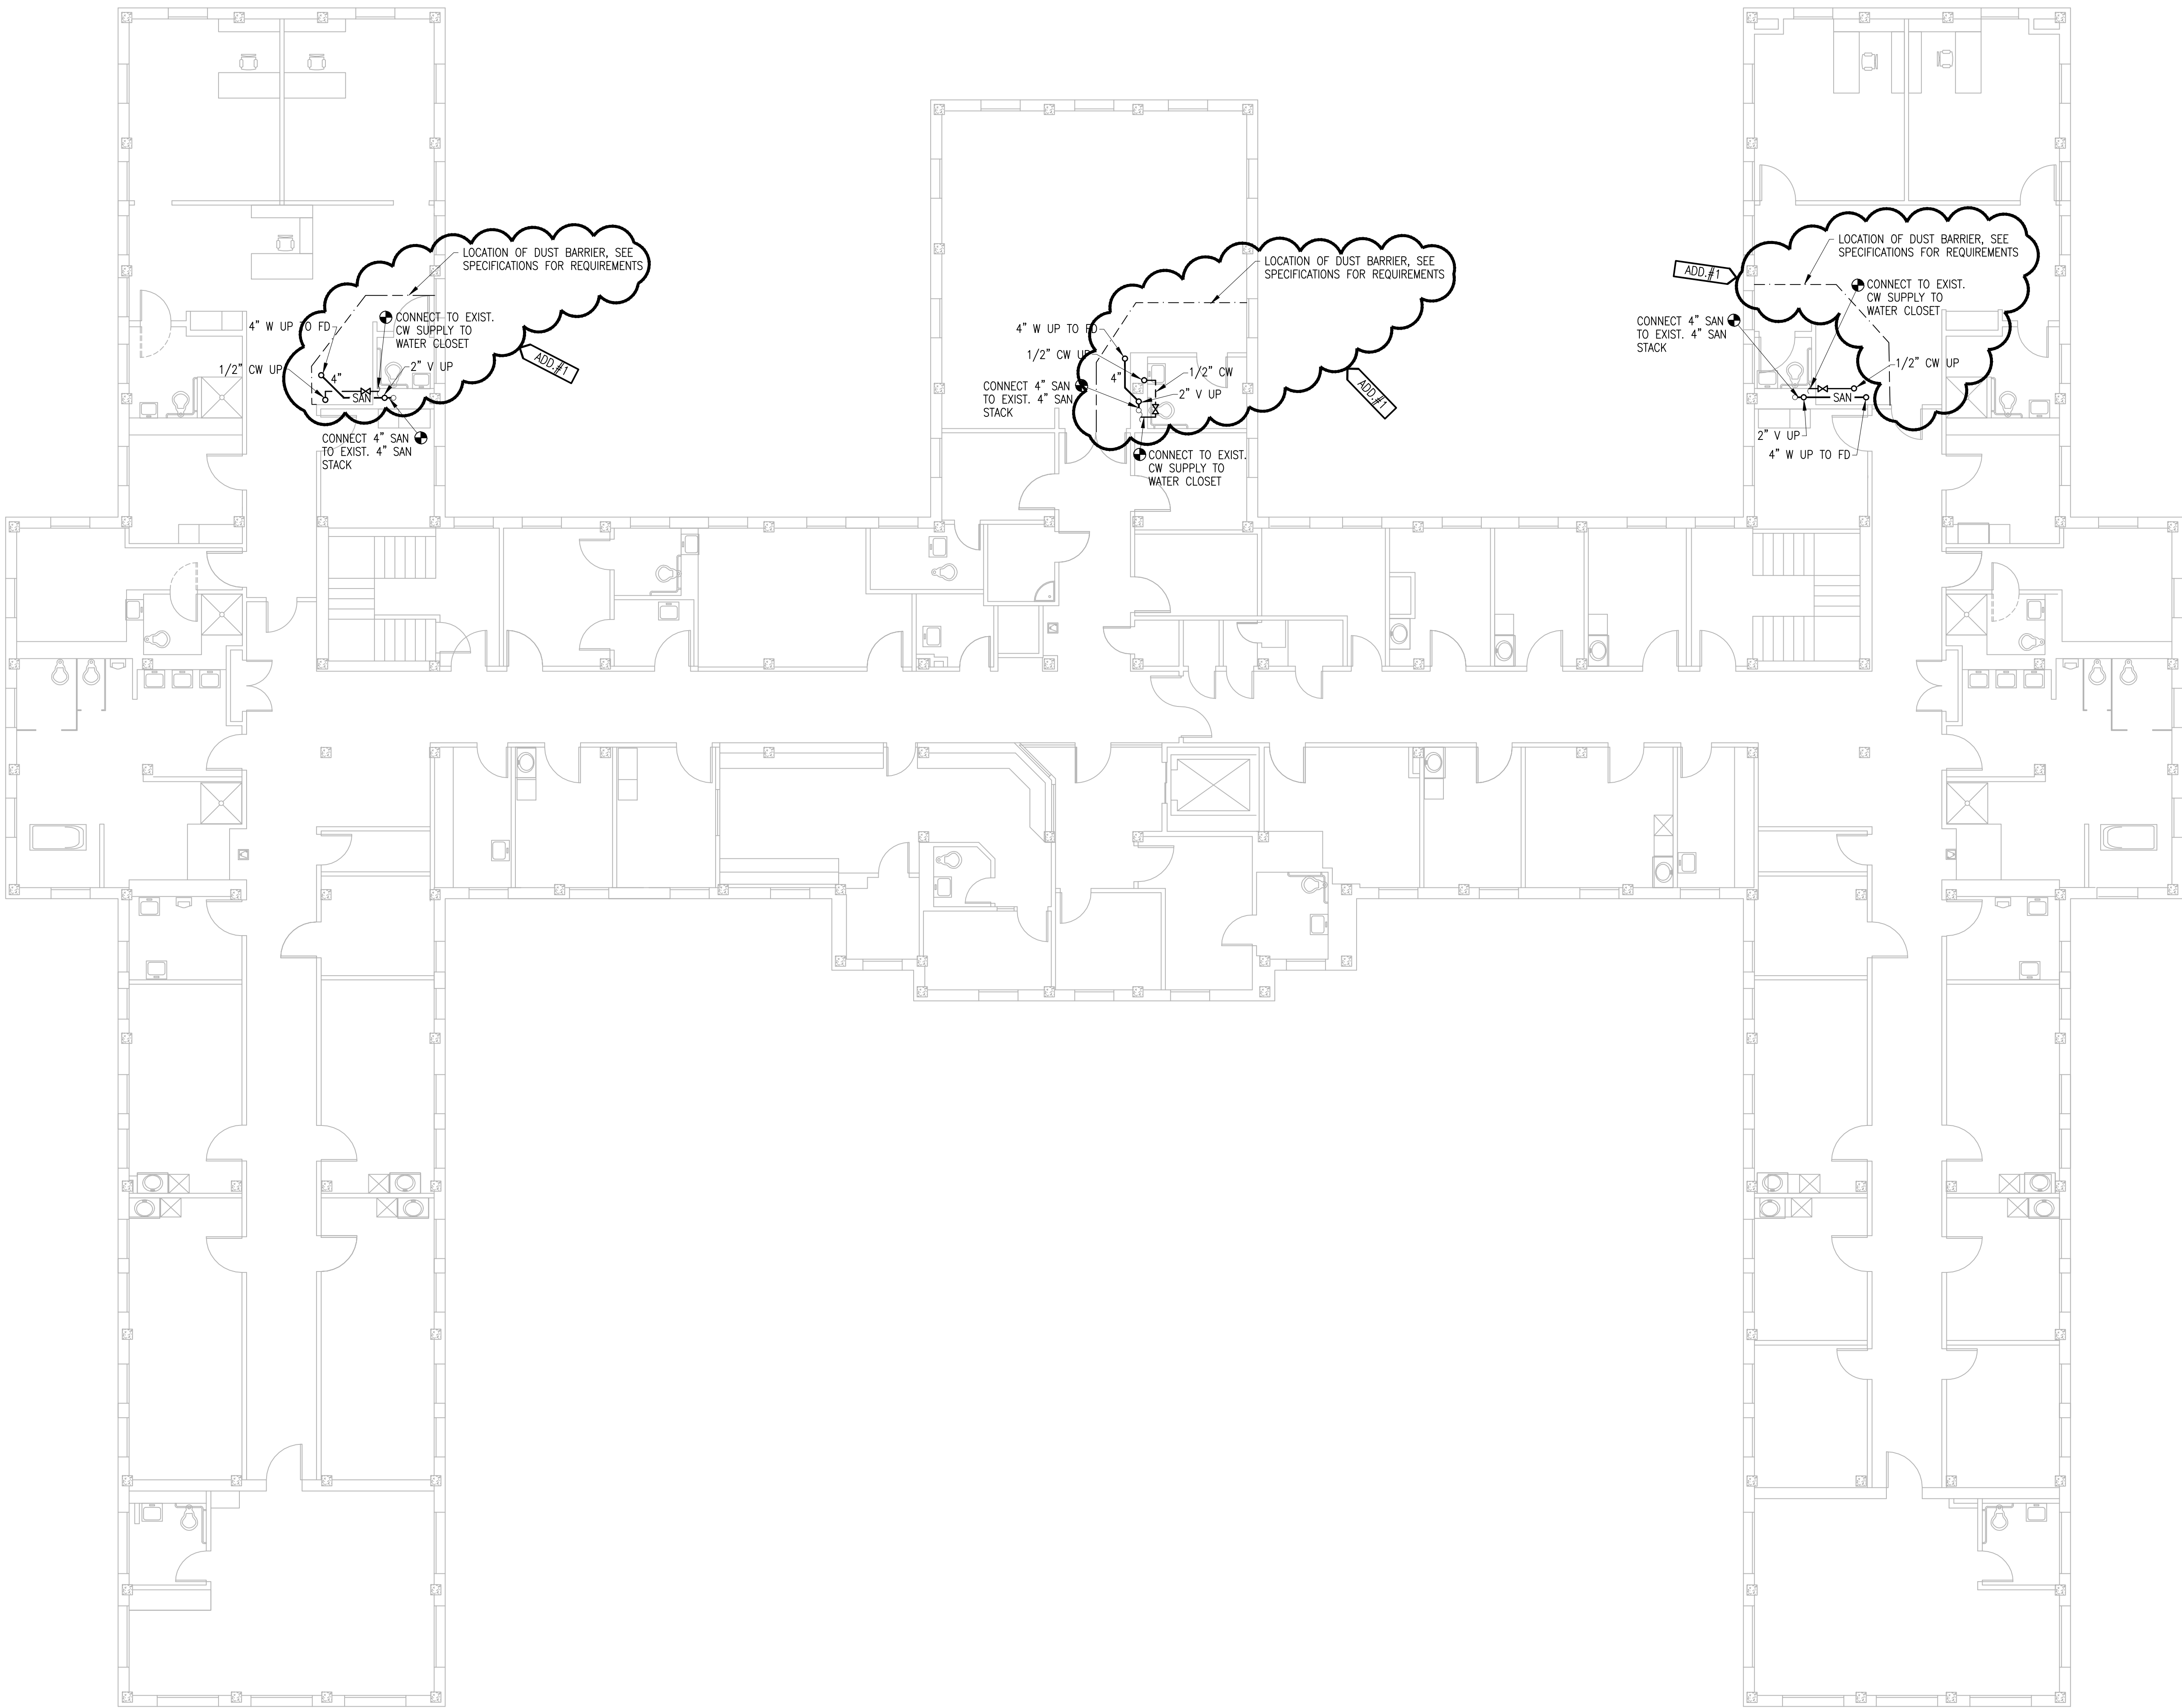

SECOND FLOOR PLAN - PLUMBING
SCALE: 1/8" = 1'-0"



APPENDIX NO. 1	06/28/2013
100% DOCUMENTS	11/30/2011
Revisions	Date

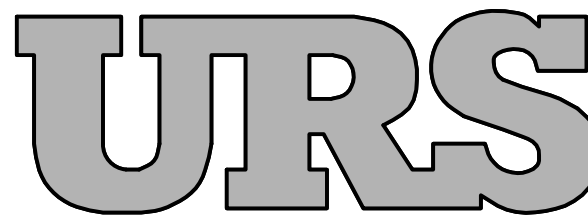

3950 SPARKS DRIVE, SE
GRAND RAPIDS, MI
616-574-8500
PROJ. NO. 12942721

Architect

URS PROJECT NO. - 12942721

stamp

	DATE	ENGINEERING MANAGER	DATE
INFECTION CONTROL	DATE	CARELINE MANAGER	DATE
SAFETY OFFICER	DATE	CHIEF OF STAFF	DATE

Drawing Title	SECOND FLOOR PLAN PLUMBING
MEDICAL CENTER DIRECTOR	DATE
ASSOCIATE MEDICAL CENTER DIRECTOR	DATE

Project Title	FCA - REPLACE HVAC SYSTEM PROJ. NO. 515-10-109 CONTRACT NO. VA251-P-0592
Building Number	82
Location	V.A.M.C. BATTLE CREEK, MICHIGAN

Date	05/04/2012
Station No.	515
P102	

