


Revisions  
VA FORM 08-6231, DEC 1989

Scale

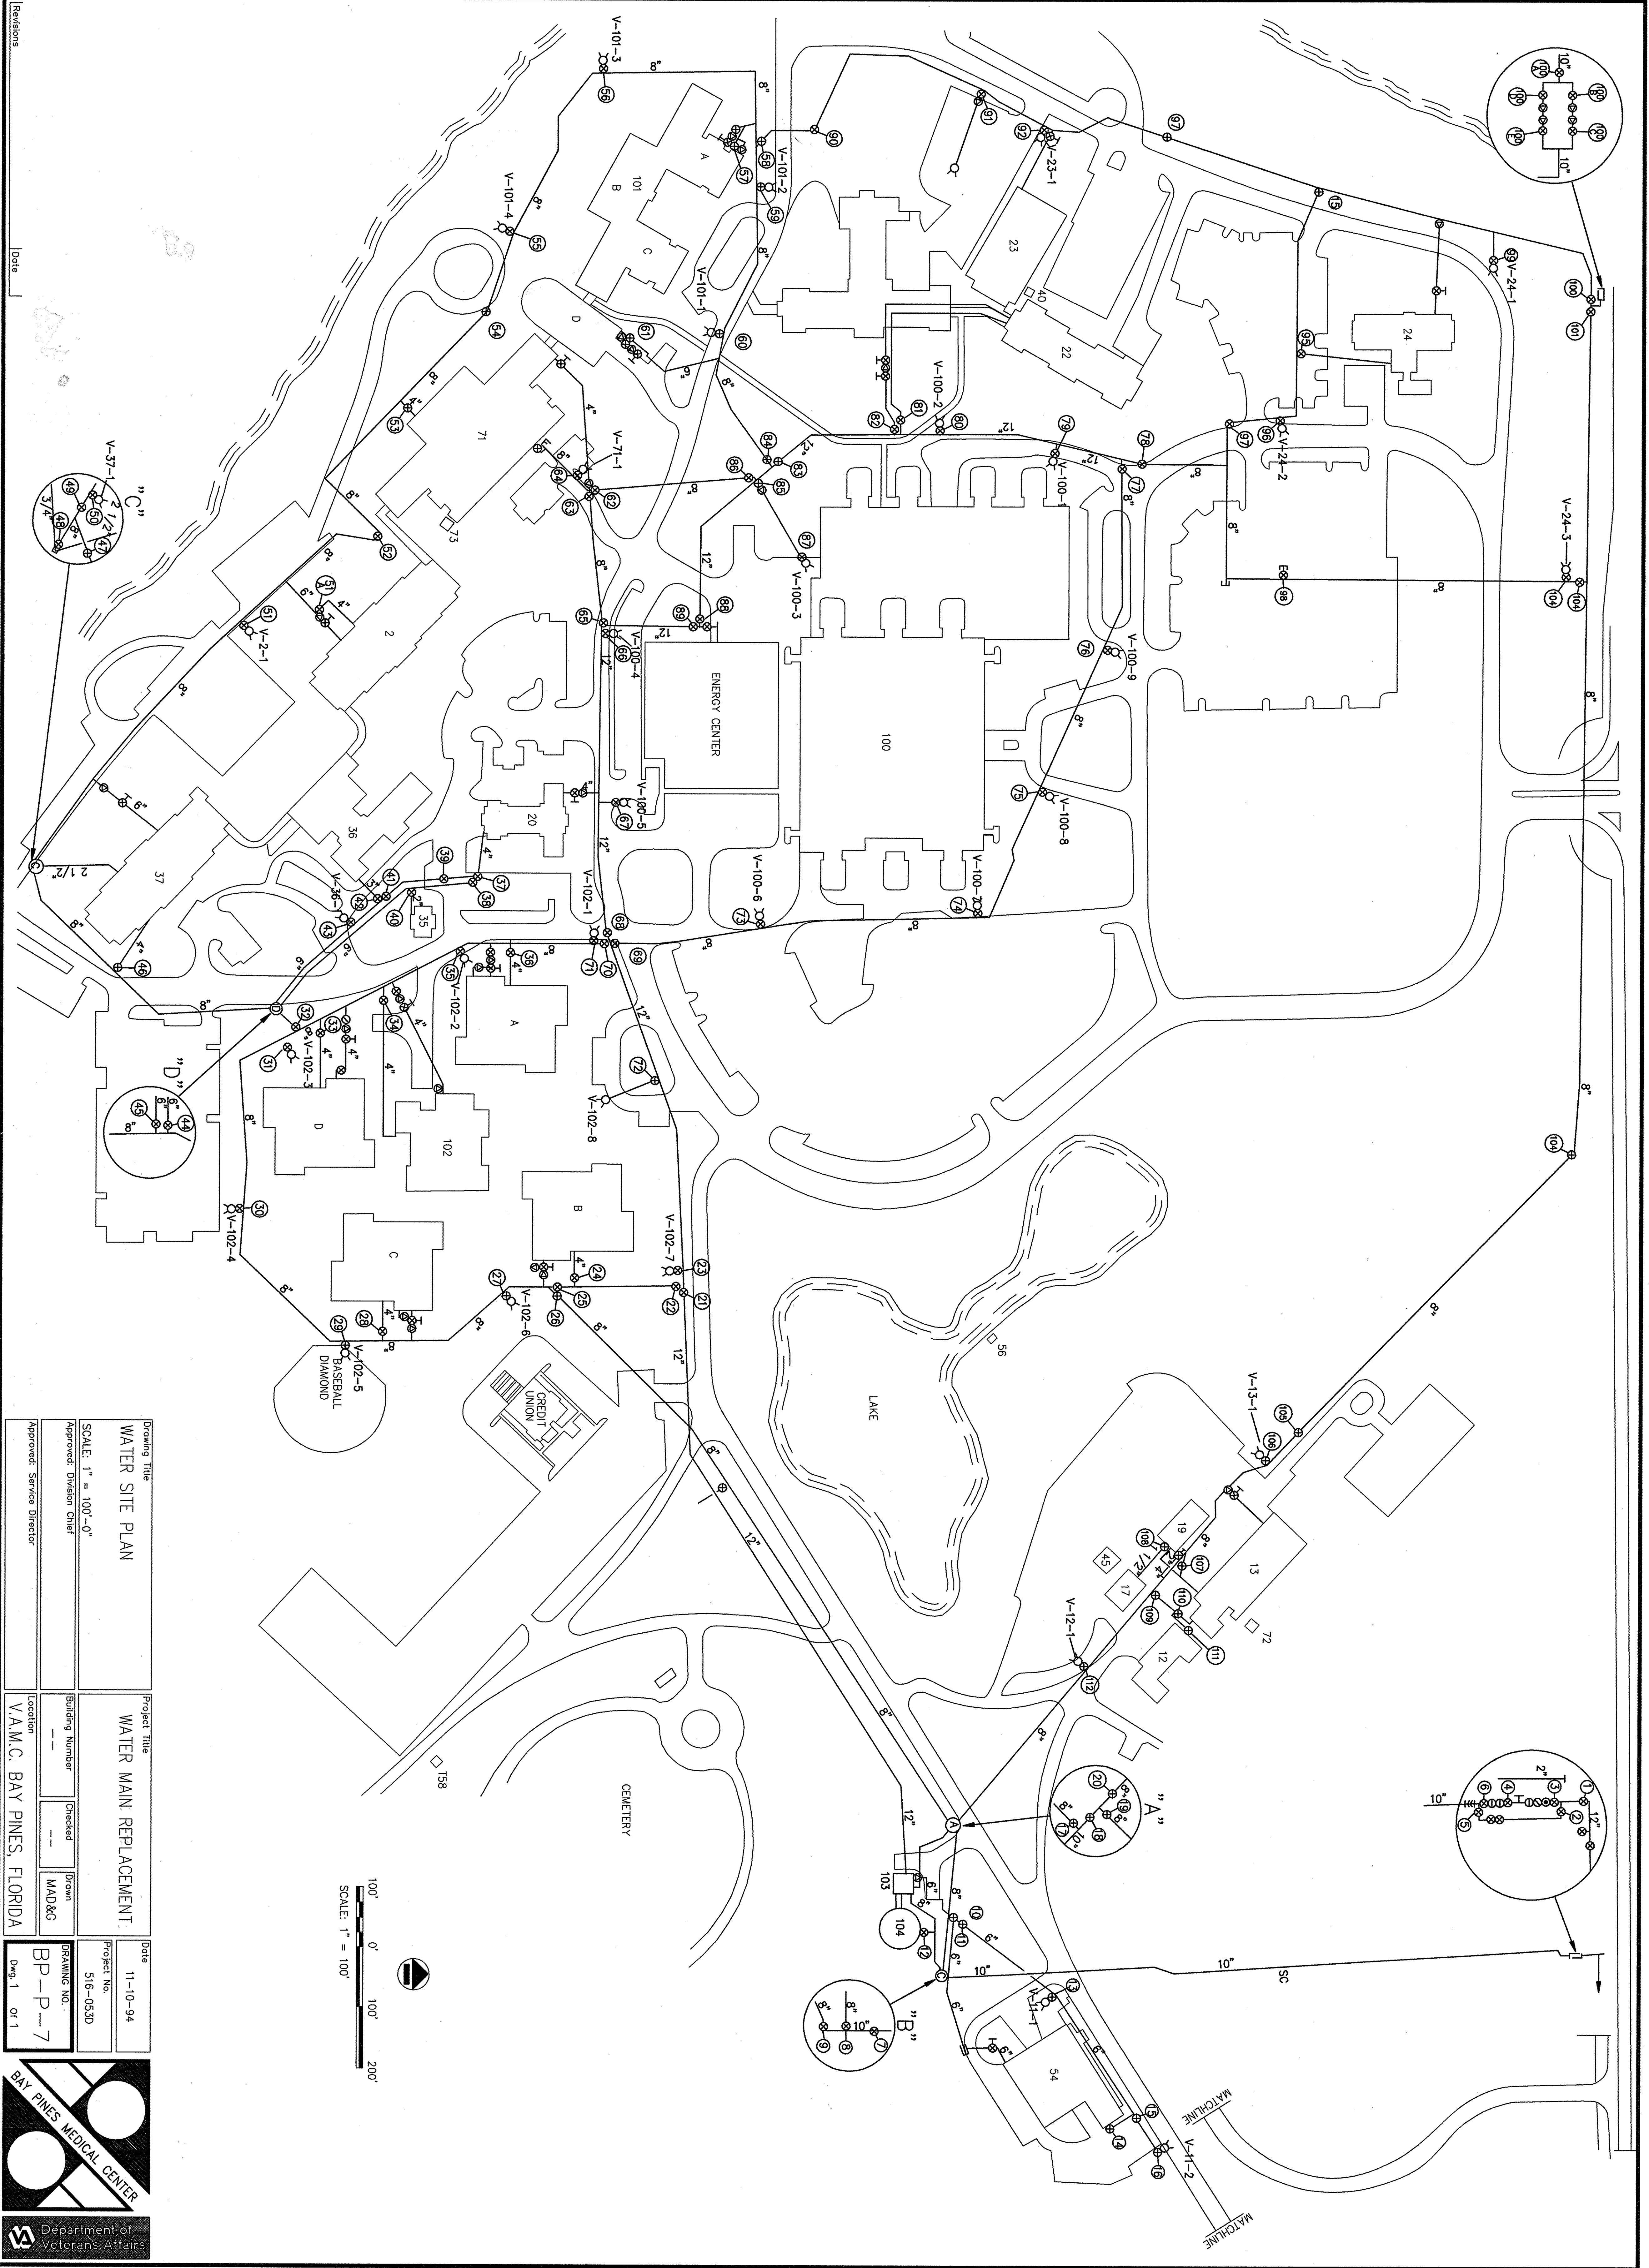

Drawing Title	Project Title	Date
WATER SITE PLAN	WATER MAIN REPLACEMENT	11-10-94
SCALE: 1" = 100'-0"	Building Number	Project No.
Approved: Division Chief	Checked	516-0530
Approved: Service Director	Drawn: MAD&G	BP-P-7
	Location	Dwg. 1 of 1
	V.A.M.C. BAY PINES, FLORIDA	

