

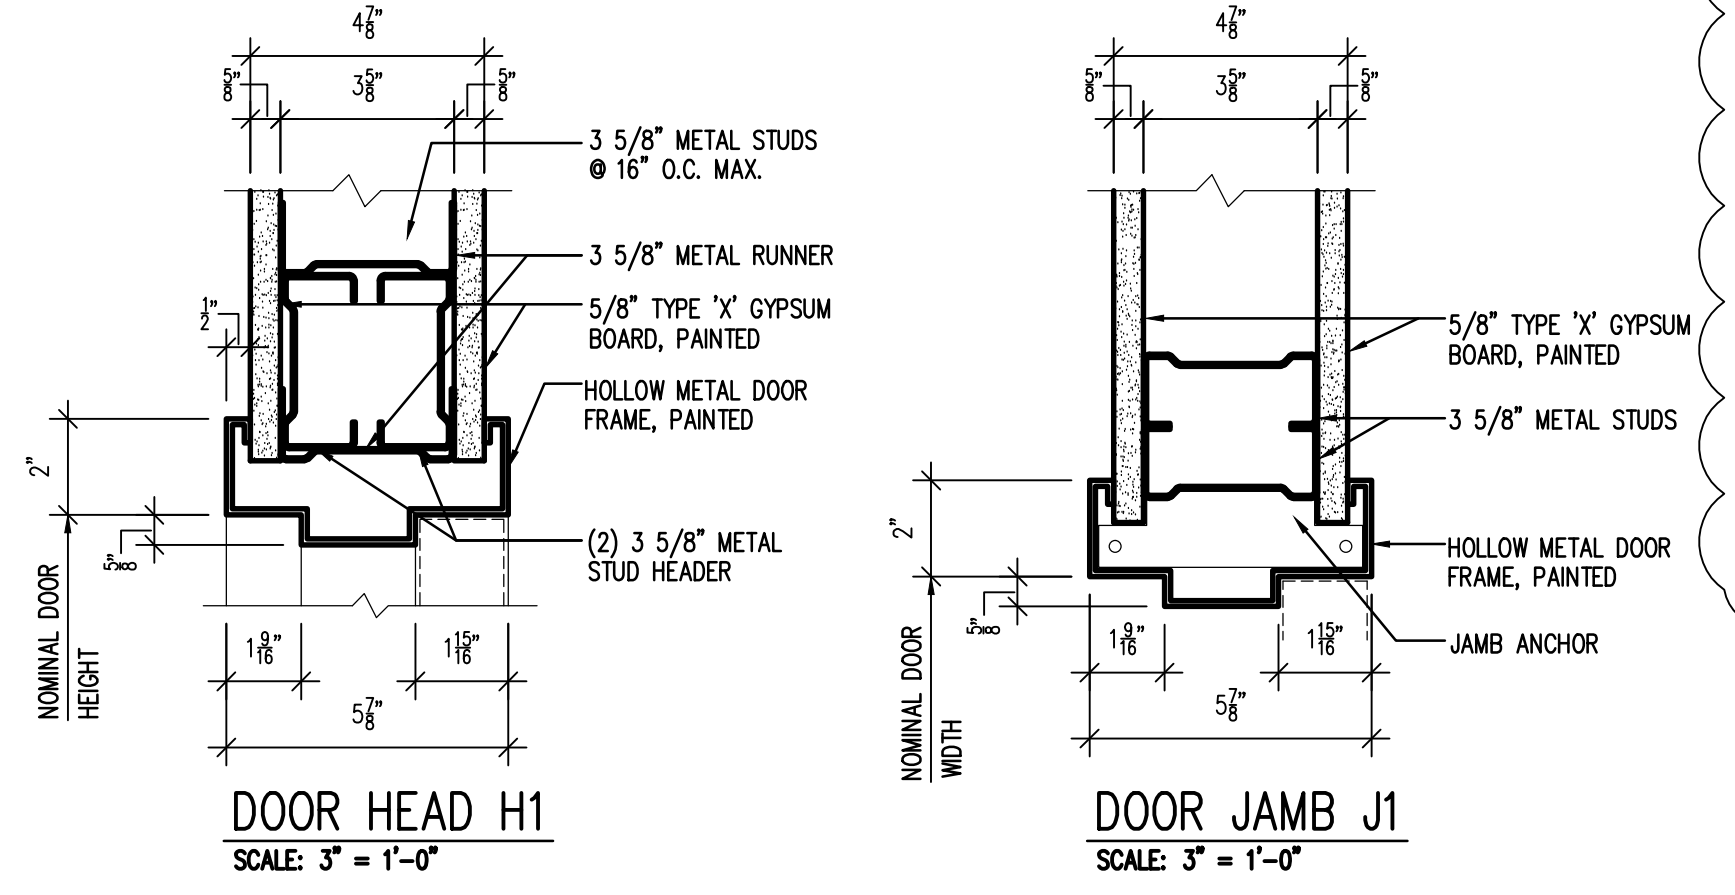
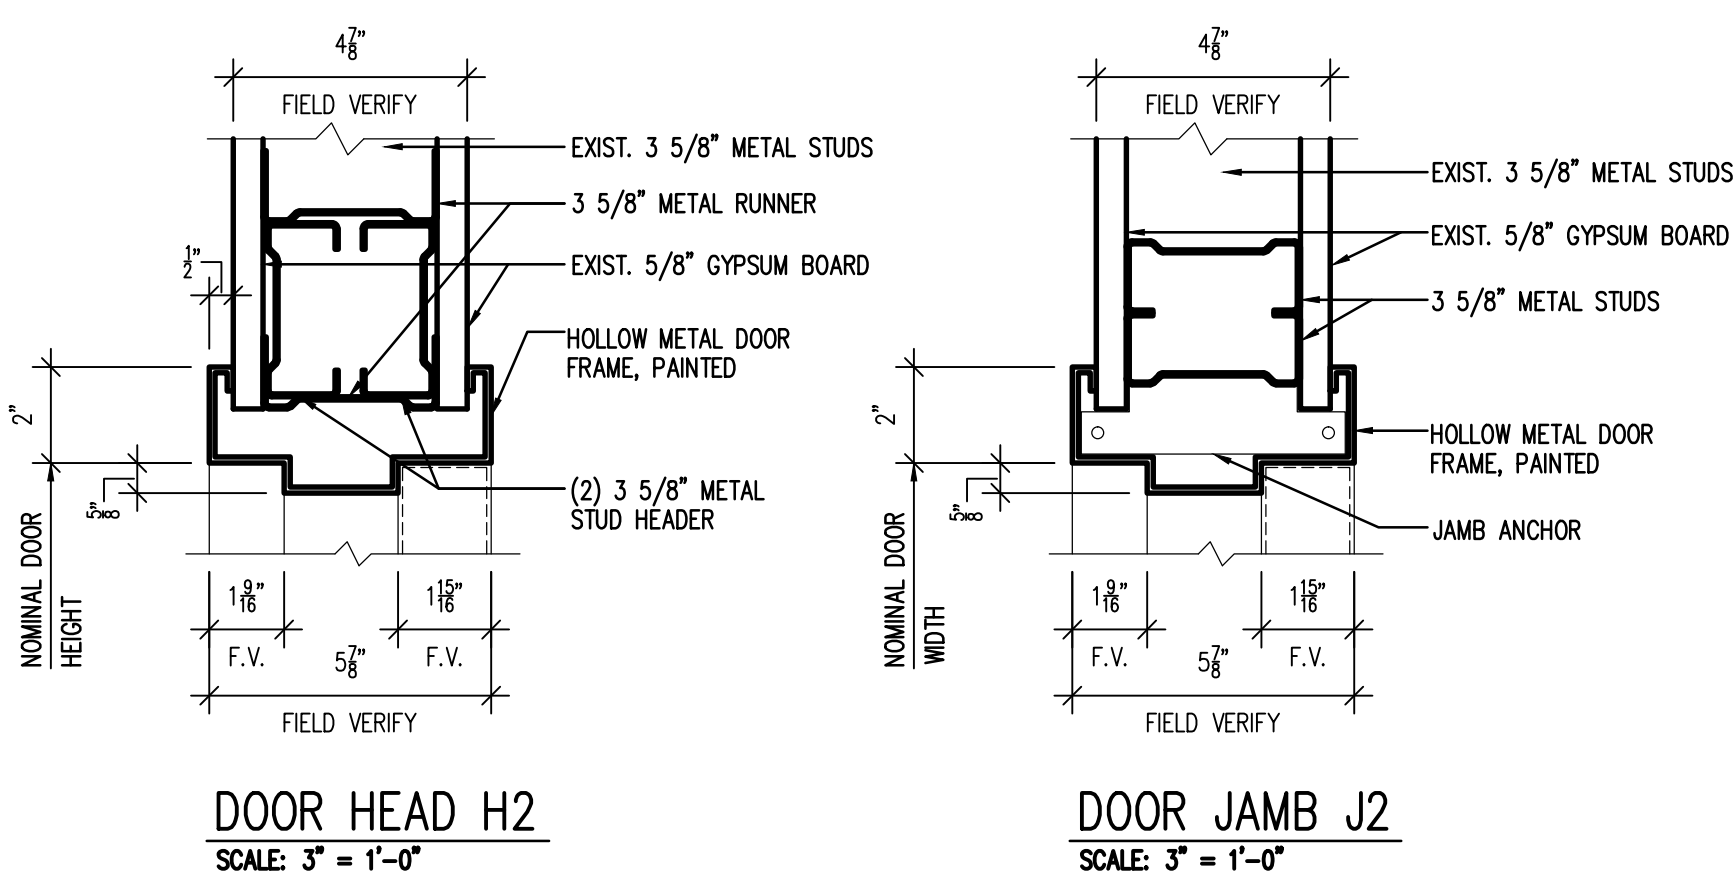
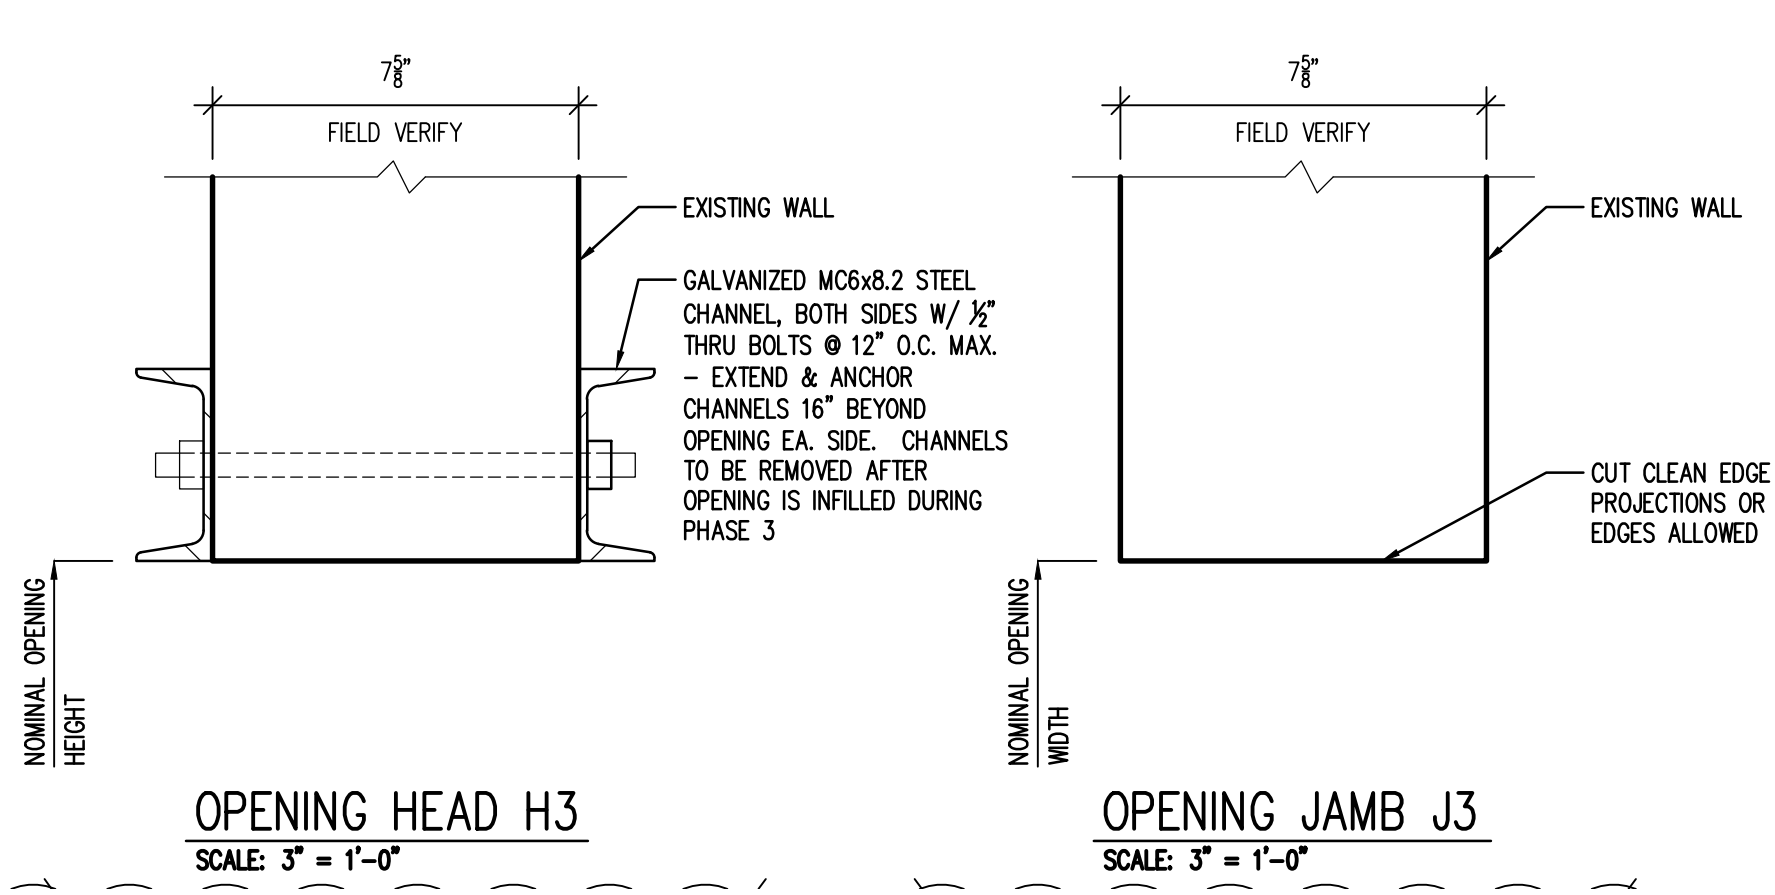
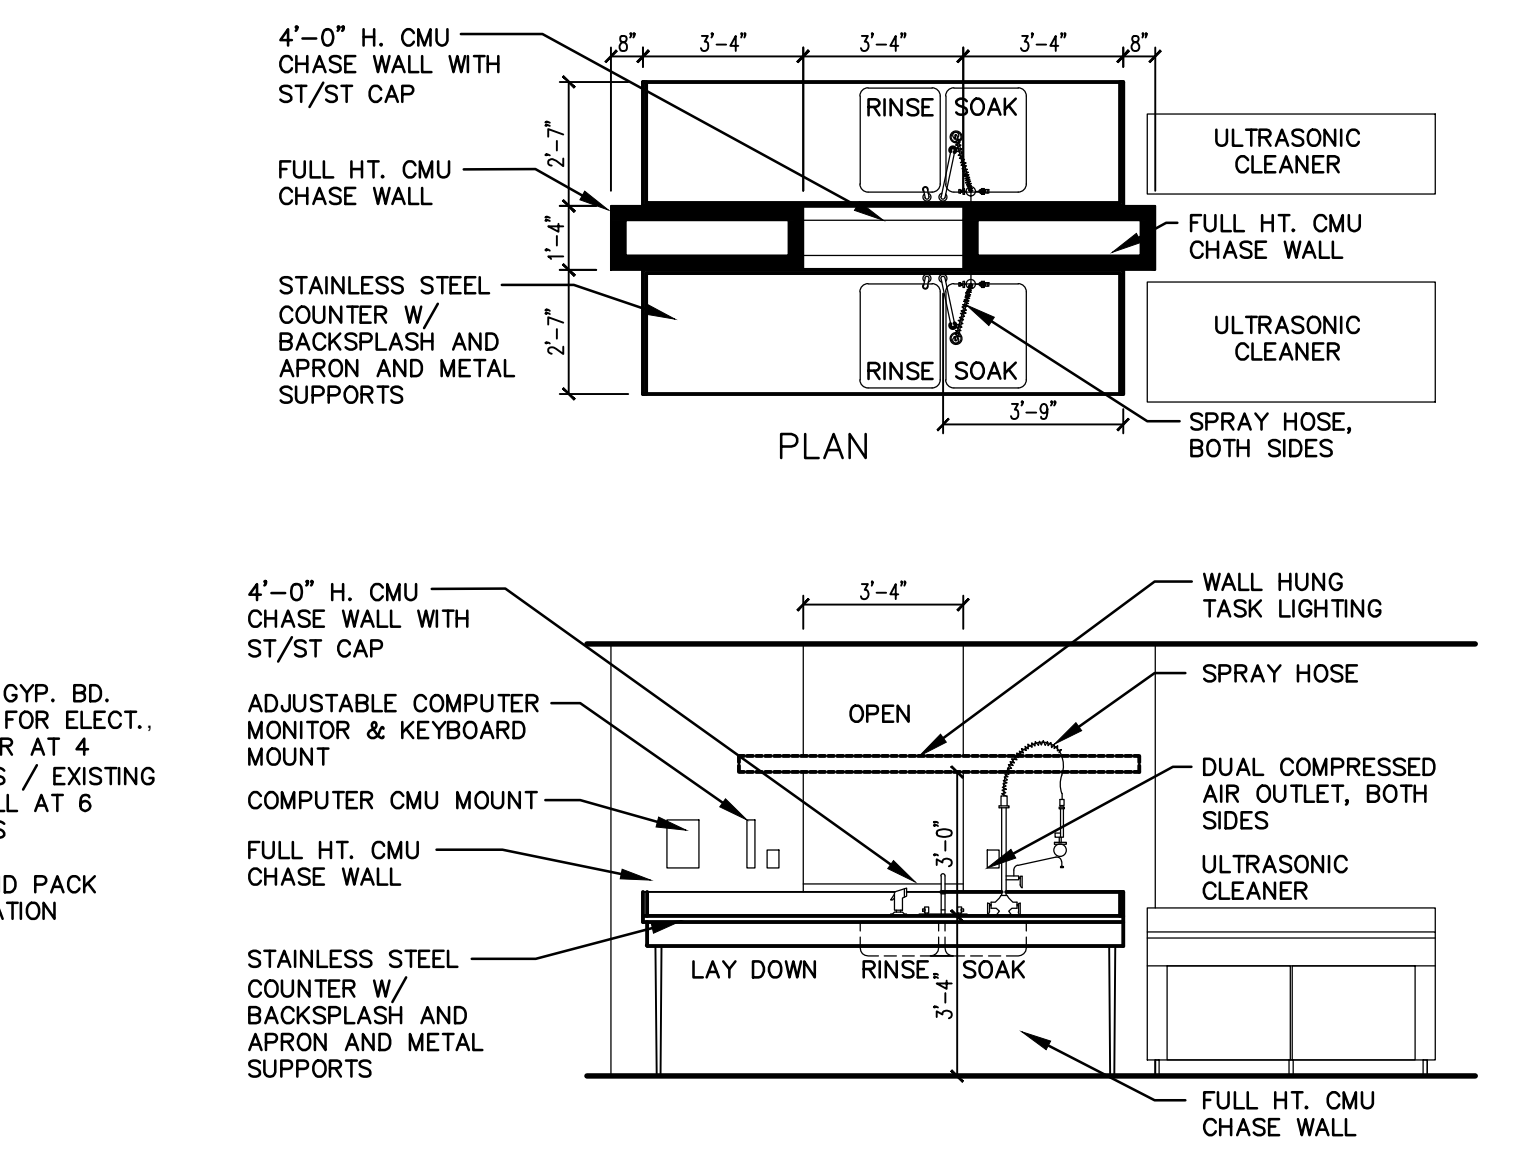
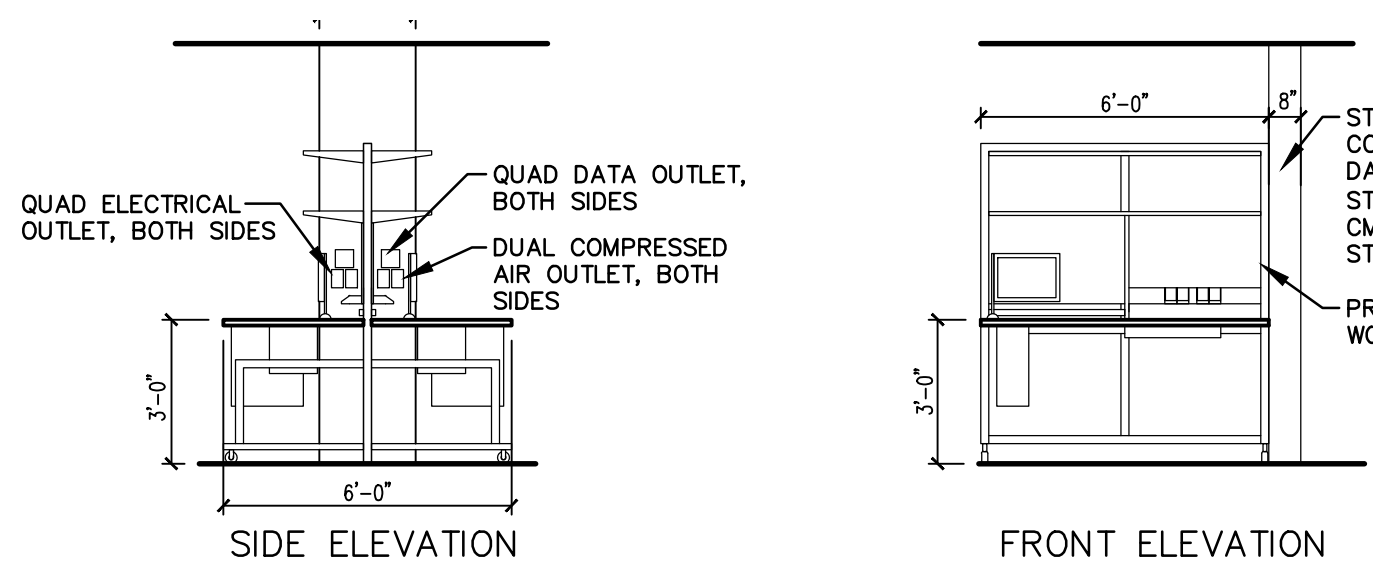
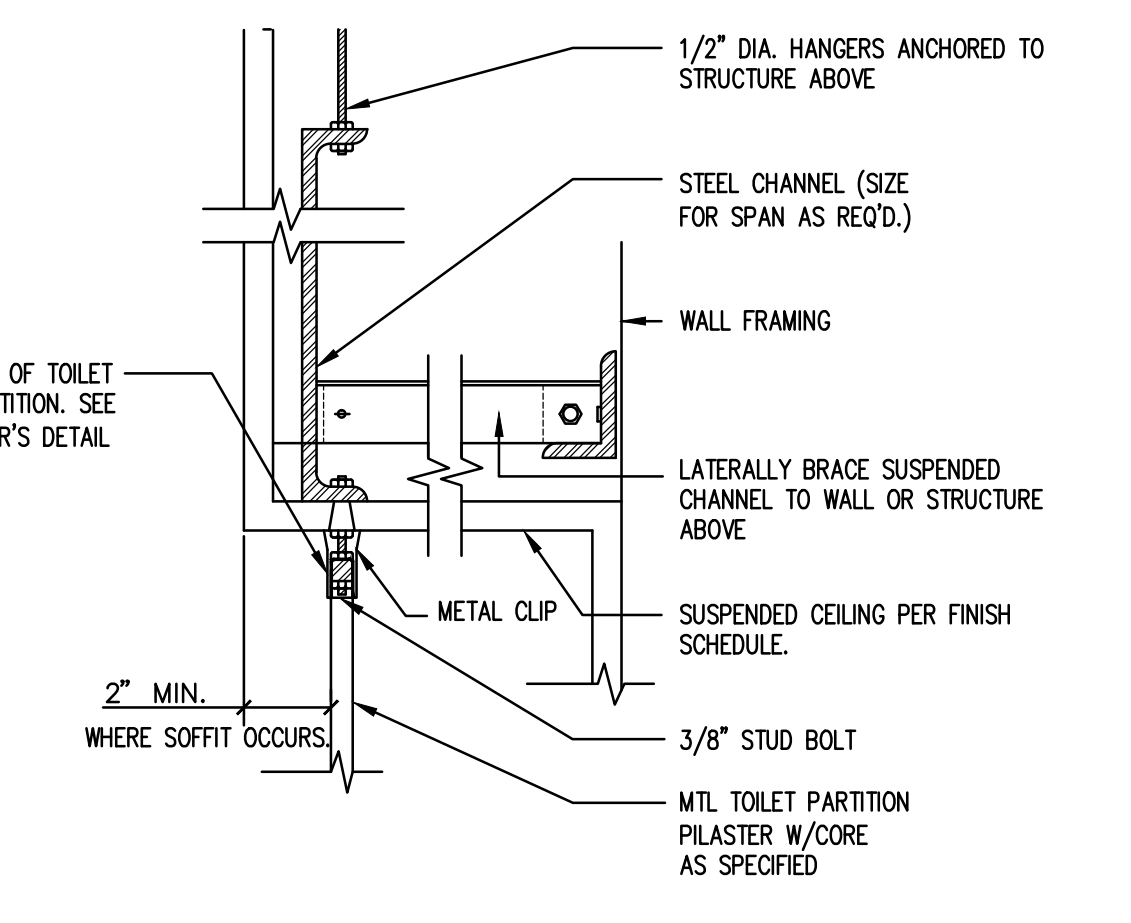
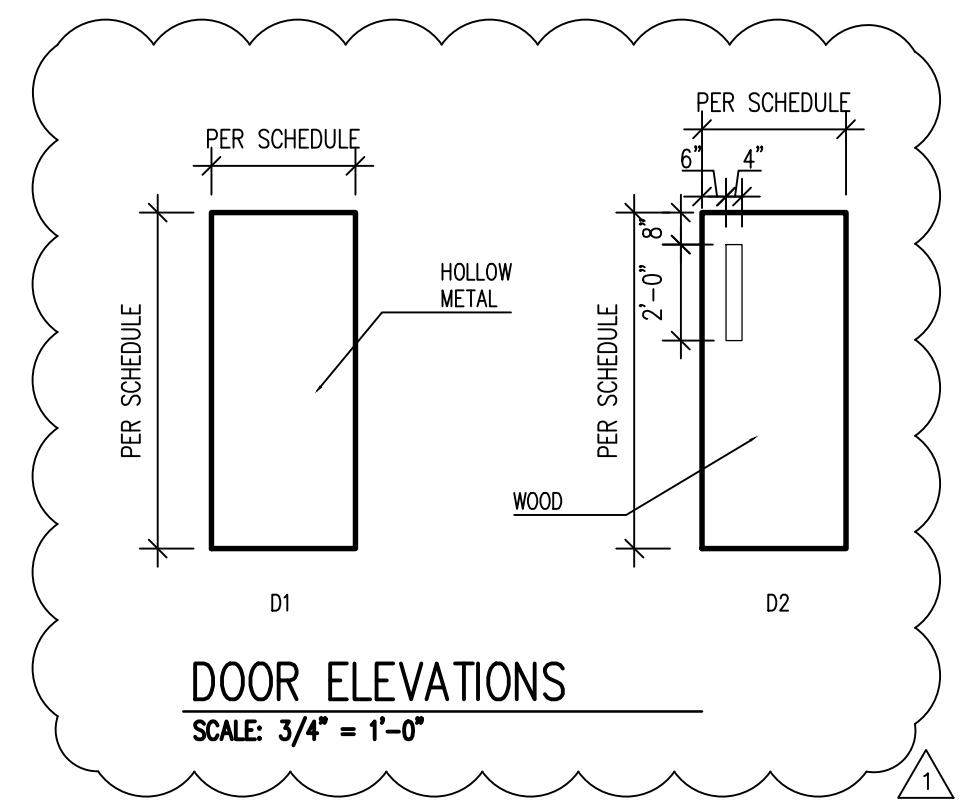
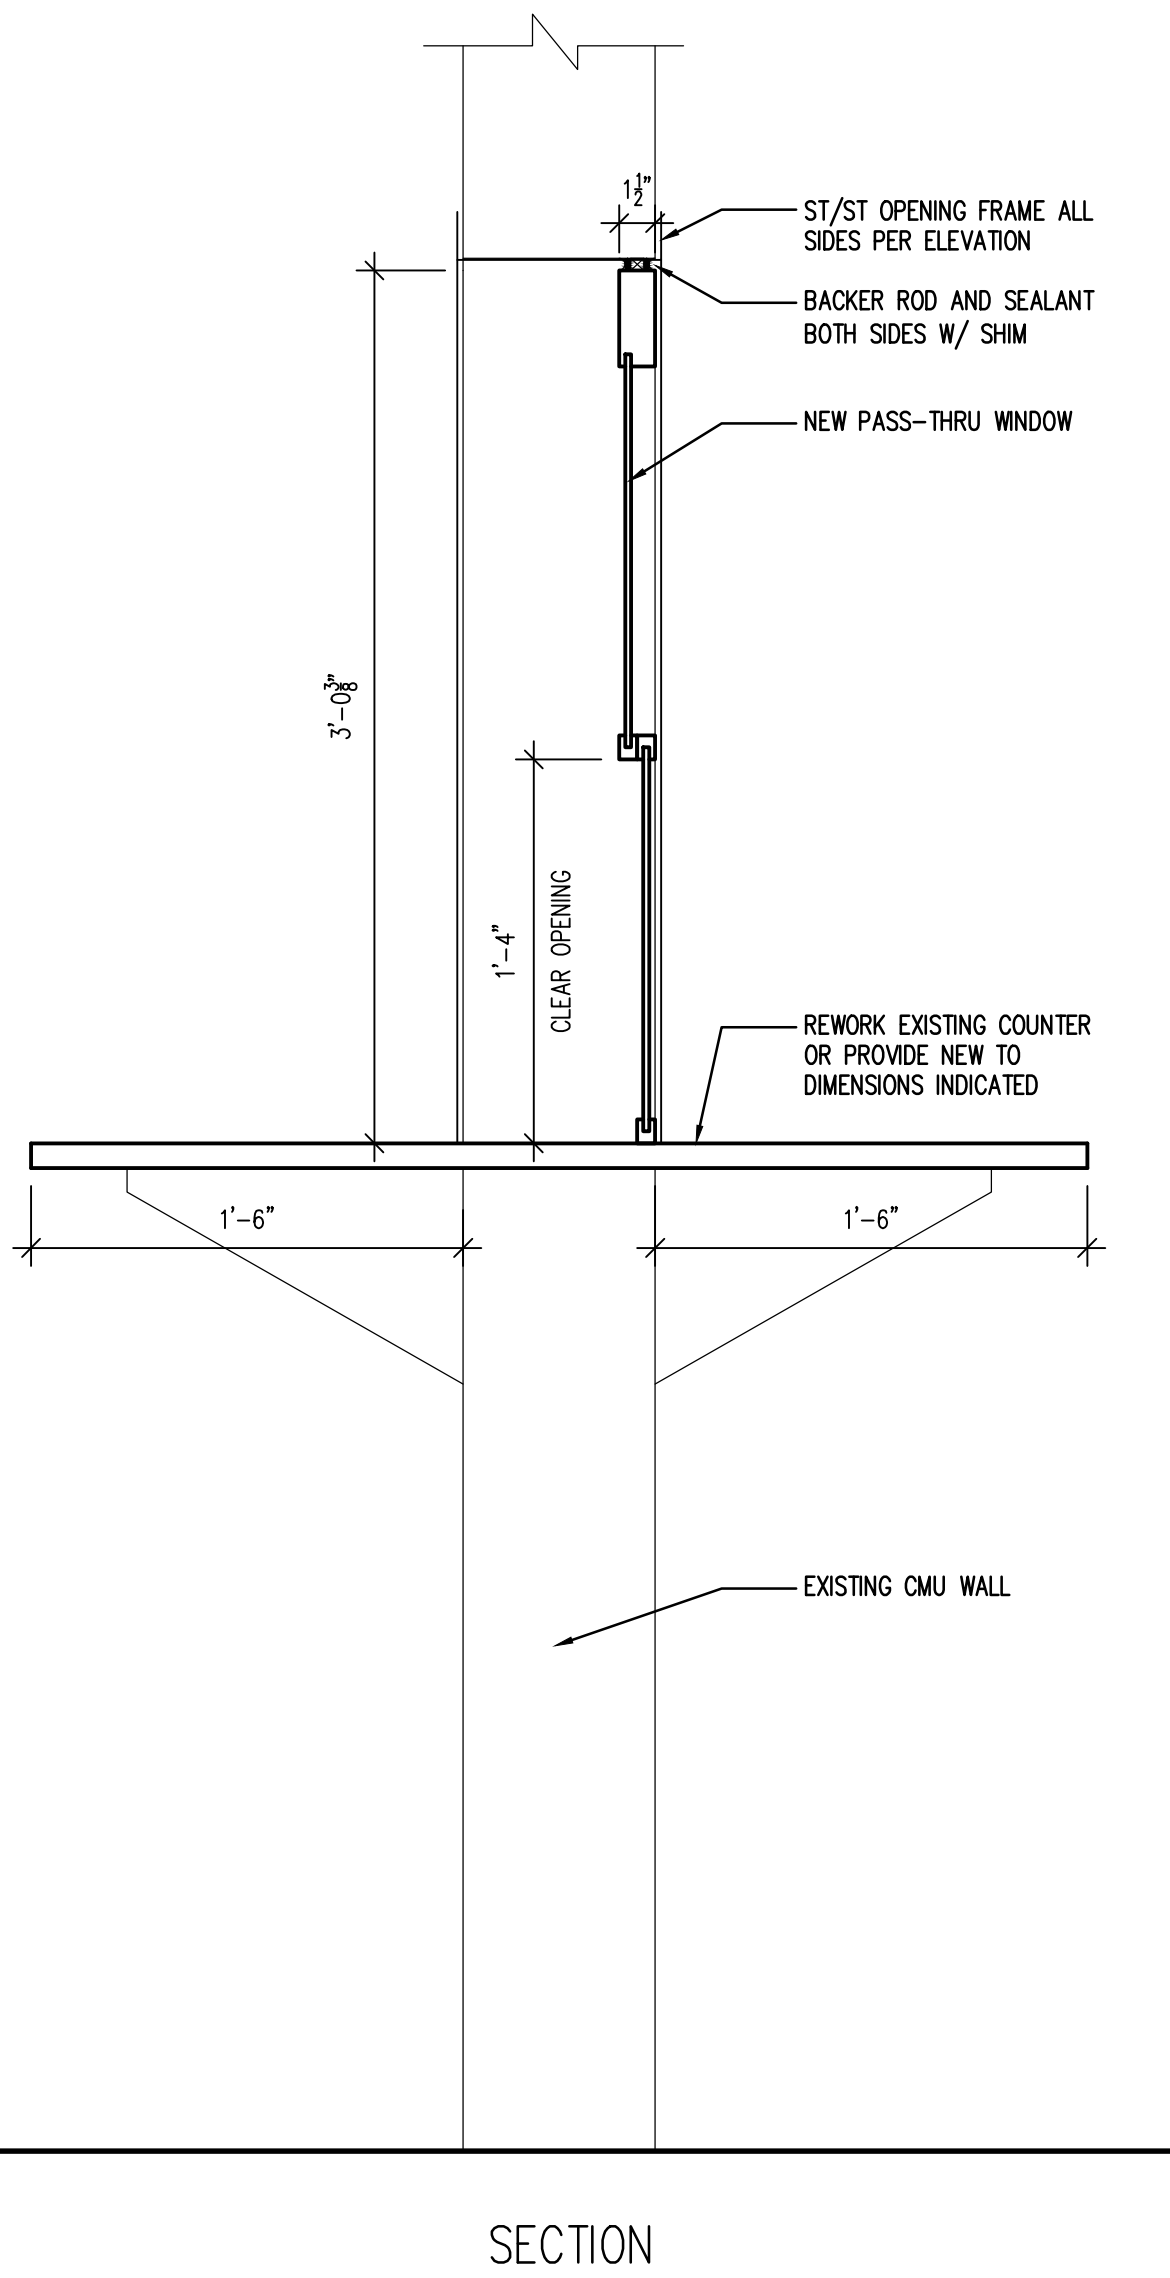
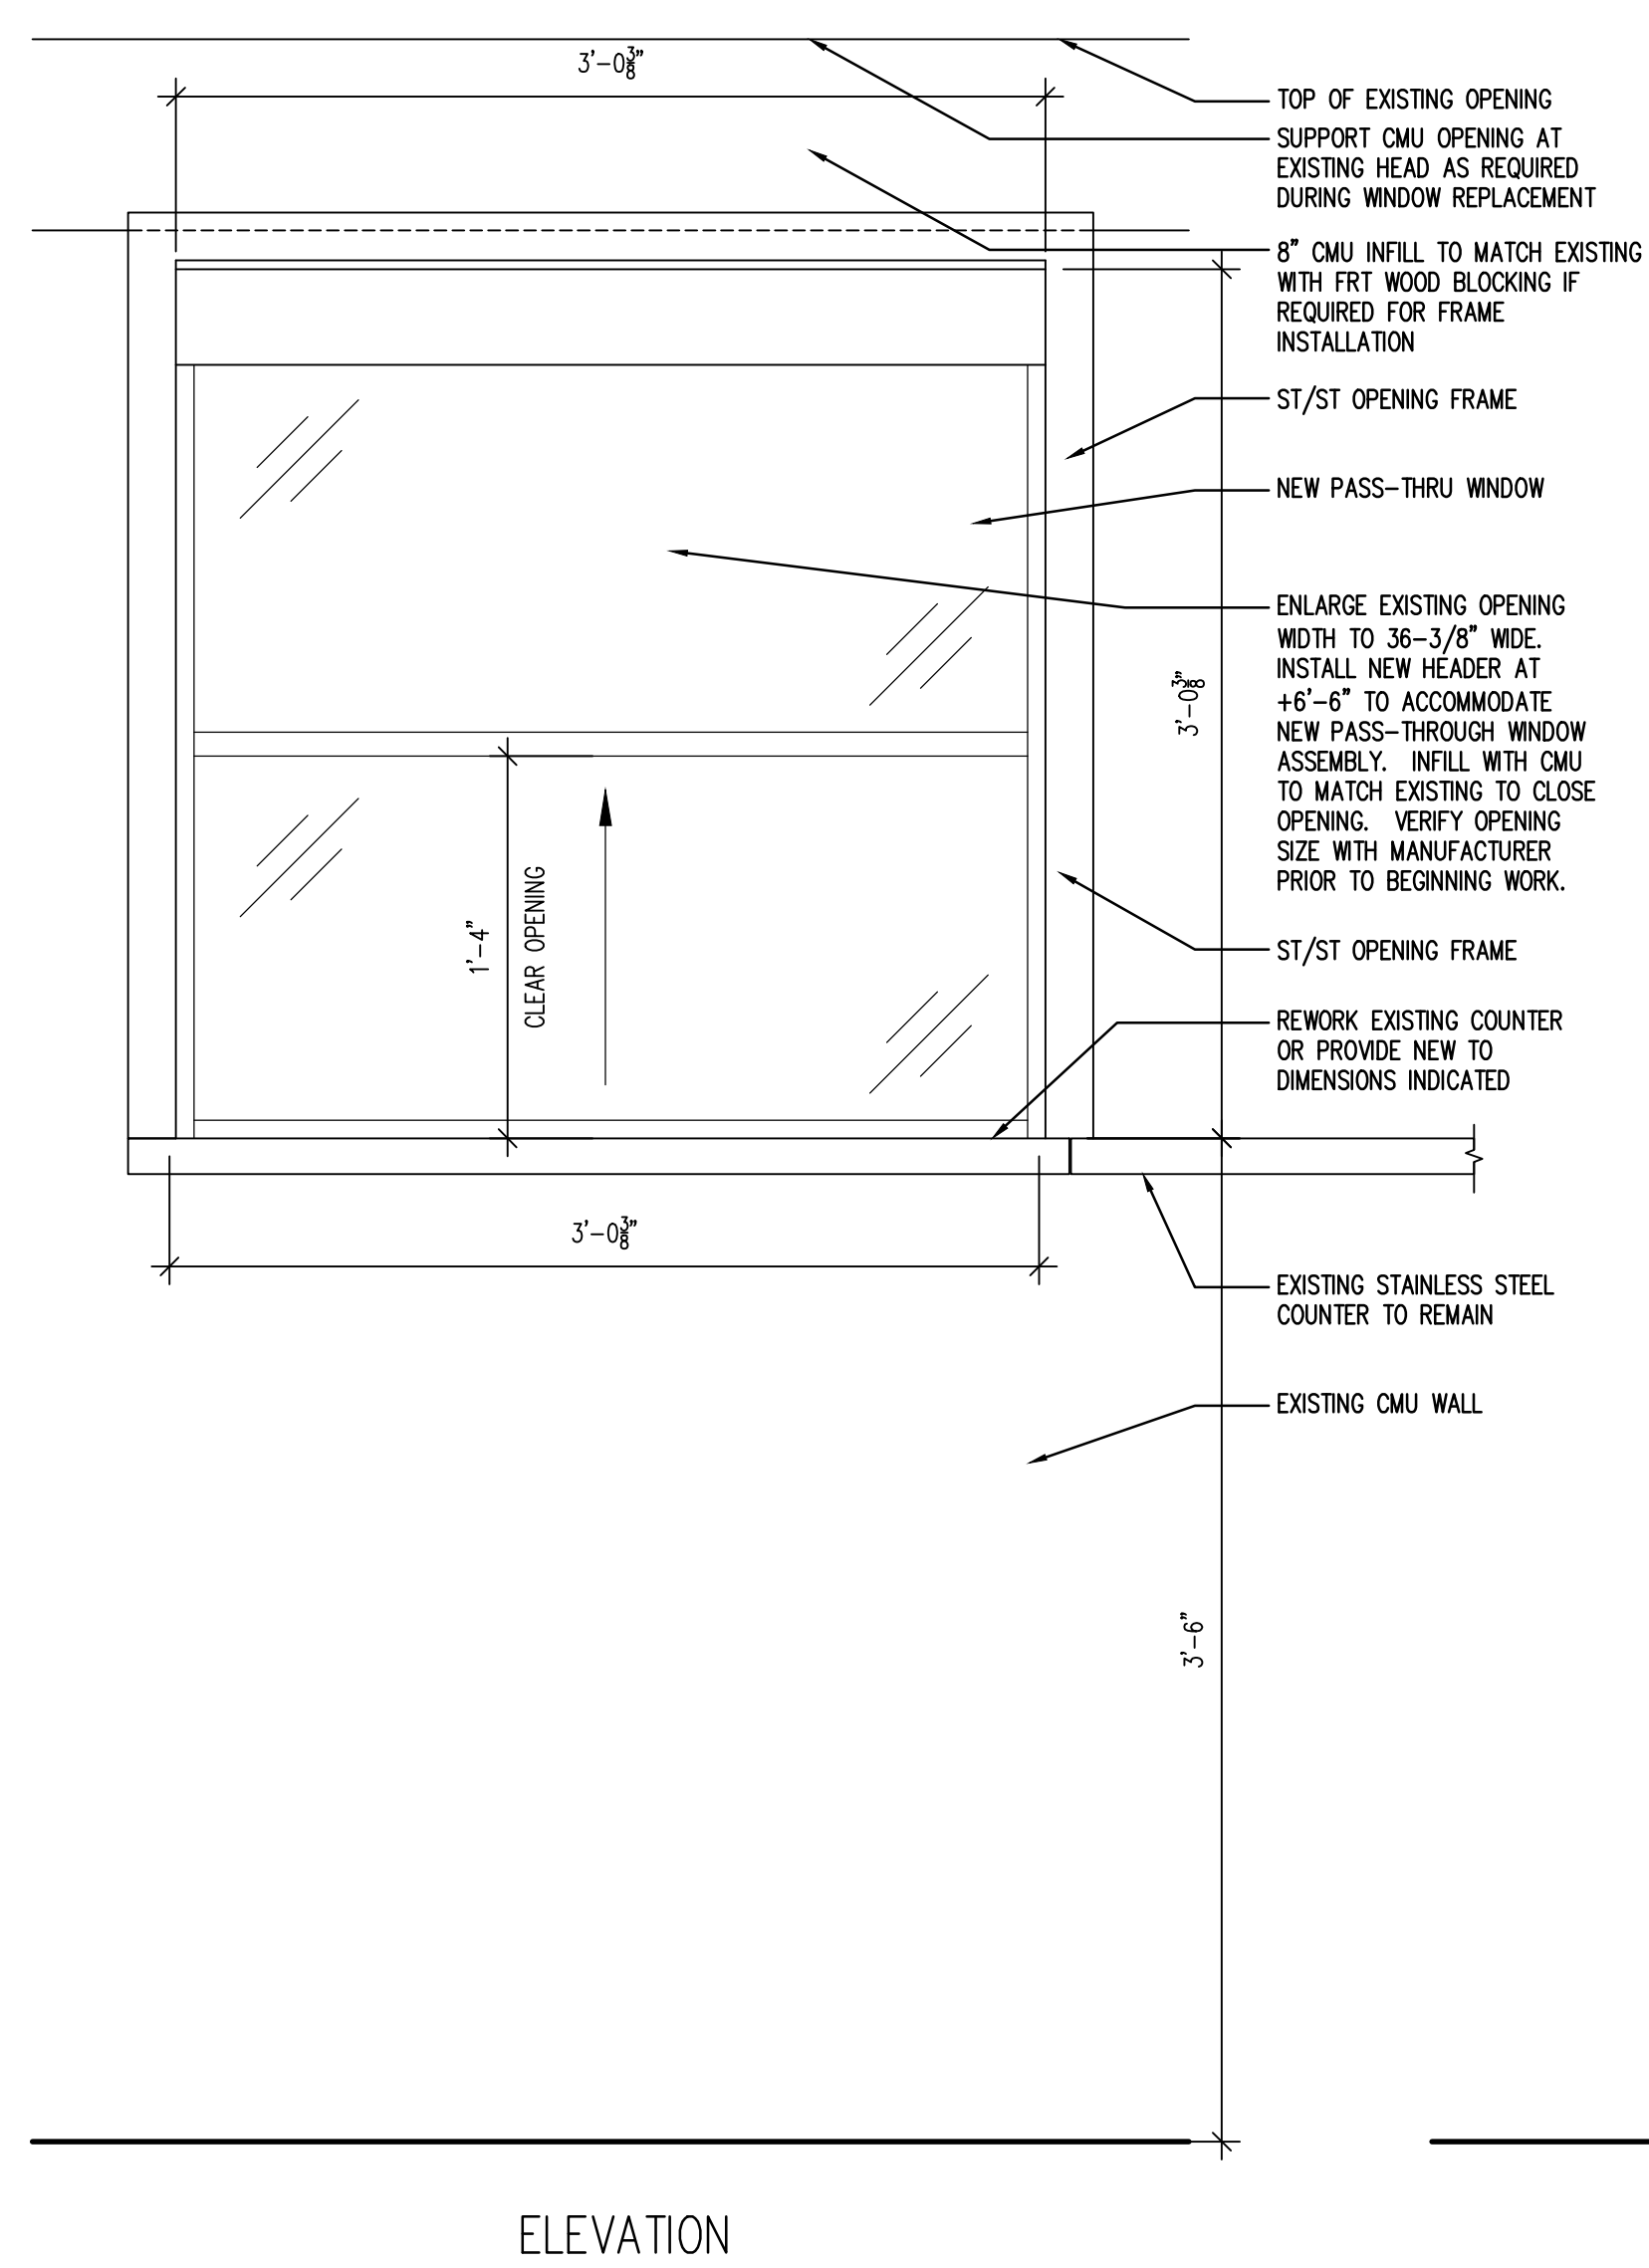


three inches = one foot  
one and one half inches = one foot  
one inch = one foot  
three quarters inch = one foot  
one half inch = one foot  
three eighths inch = one foot  
one quarter inch = one foot  
one eighth inch = one foot

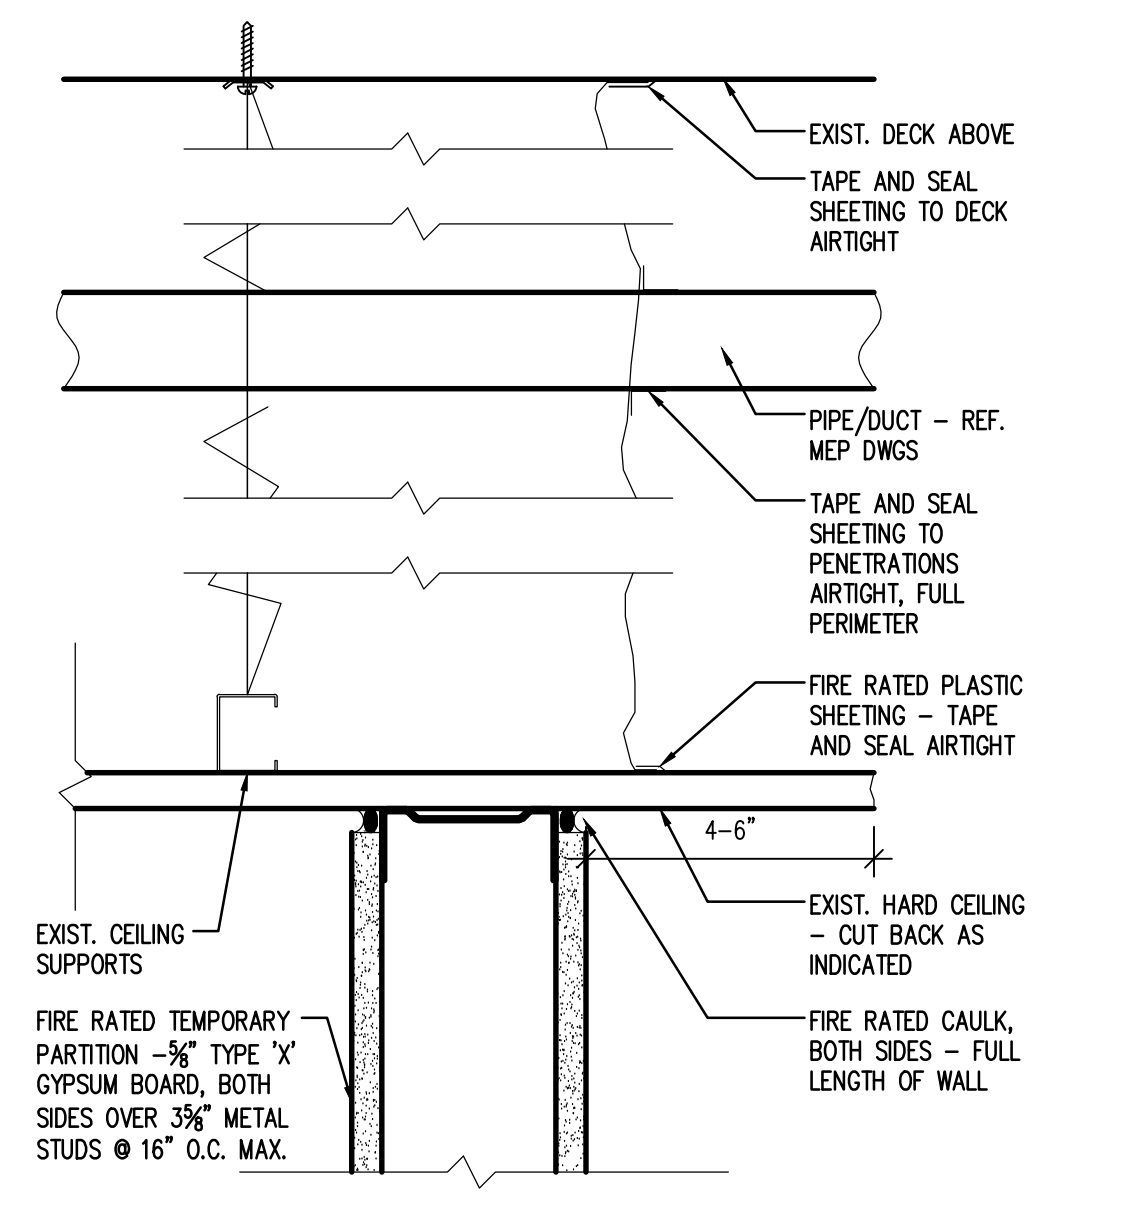

DOOR SCHEDULE											
DR. NO.	DOOR/OPENINGS			FRAME		DETAIL		HARDWARE SET			REMARKS
	SIZE	MAT'L	ELEV	MAT'L	ELEV	JAMB	HEAD				
B060	3'-6" x 7'-0" x 1 3/4"	EX.	EX.	EX.	EX.	EX.	EX.	3	1.		
B063	PR 3'-0" x 7'-0" x 1 3/4"	EX.	EX.	EX.	EX.	EX.	EX.	3	1.		
B072	3'-0" x 7'-0" x 1 3/4"	HM	D1	HM	F1	J2	H2	2	---		
B082A	PR 3'-0" x 7'-0" x 1 3/4"	EX.	EX.	EX.	EX.	EX.	EX.	4	1.		
B082B	3'-6" x 7'-0" x 1 3/4"	EX.	EX.	EX.	EX.	EX.	EX.	4	1.		
CB-30A	3'-6" x 7'-0" x 1 3/4"	EX.	EX.	EX.	EX.	EX.	EX.	3	1.		
CB-30B	3'-6" x 7'-0" x 1 3/4"	WD	D2	HM	F1	J1	H1	1	---		
CB-30C	3'-6" x 7'-0" x 1 3/4"	WD	D2	HM	F1	J1	H1	1	---		

REMARKS:  
1. EXISTING DOOR, VERIFY SIZE IN FIELD.

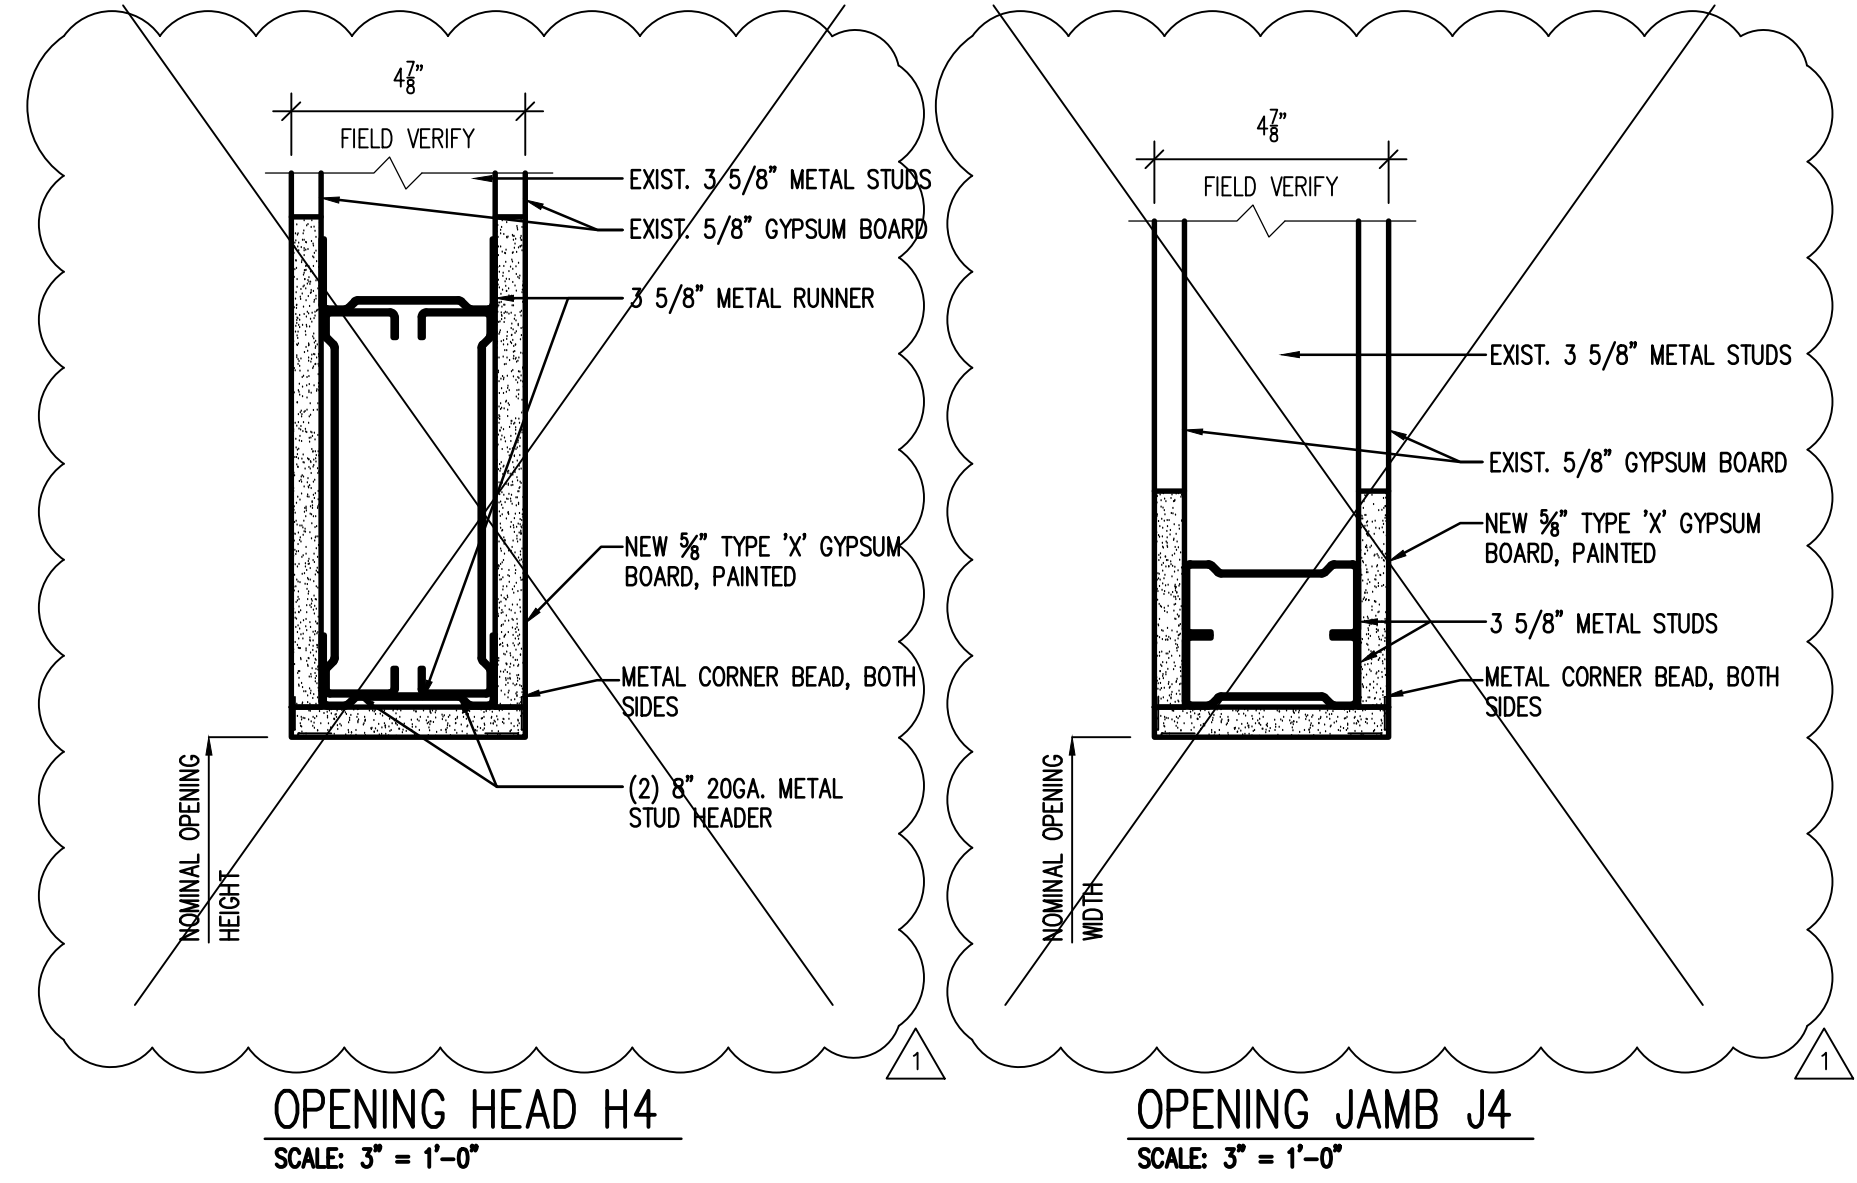

35% SD SUBMITTAL 1/11/2012

35% SD REVISION 1 1/12/2012

65% DD SUBMITTAL 12/20/2012

35% CD SUBMITTAL 01/30/2013

100% CD SUBMITTAL 02/27/2013

BIDDING DOCUMENTS 06/10/2013

AMENDMENT 2 06/07/2013

Revisions: \_\_\_\_\_ Date: \_\_\_\_\_

Dept. of Veterans Affairs  
Richard L. Roudebush  
VA Medical Center  
1481 W. 10th Street  
Indianapolis, IN 46202

CERTIFIED BY:

NORTH REFERENCE

ARCHITECT/ENGINEERS:

USGD LLC

9245 Calumet Ave., Suite 205,  
Munster, IN 46321  
(219) 836-2120 Fax (219) 836-1129

AMERICAN STRUCTUREPOINT INC.

7260 Shadeland Station | Indianapolis, Indiana 46226  
TEL 317.547.5580 | FAX 317.543.0270  
www.structurepoint.com

Drawing Title  
INTERIOR ELEVATIONS AND DETAILS - ALL PHASES

PROJECT ENGINEER  
John Fiwowski

SCALE

Approved Engineering Chief

Approved Service Chief

Project Title  
RENOVATE SFS

Location  
BASEMENT A-WING

Date  
6/10/2013

Checked  
FMF

Drawn  
VFS

Project Number  
583-12-107

Building Number  
1

Drawing Number  
AS-401

3FY12

20 of 55

BIDDING DOCUMENTS FULLY SPRINKLERED

Engineering and Facilities Management Services

Department of Veterans Affairs